


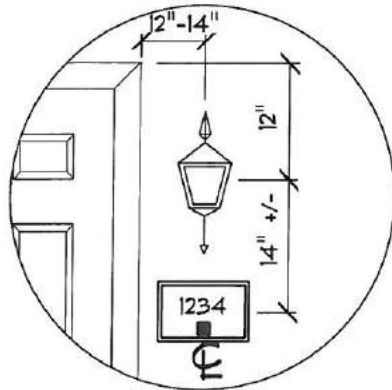

"911" EMERGENCY NUMBER DETAIL
SCALE: N.T.S.



FRONT ELEVATION
SCALE: 3/16" = 1'-0"

THESE DRAWINGS HAVE BEEN DEVELOPED BY PATCO CONSTRUCTION INC.
FOR THE TITLED SET ONLY, THE DRAWINGS ARE THE SOLE PROPERTY OF
PATCO CONSTRUCTION INC. AND THEY SHALL NOT BE USED, LENT, ALTERED,
OR REPRODUCED WITHOUT WRITTEN CONSENT OF PATCO CONSTRUCTION.

Friday, August 22, 2014 08:59 AM

REVISIONS:

PATCO
CONSTRUCTION, INC.



1293 MAINE ST. SANFORD, ME. 04073 - 12071324-5574 FAX 12071324-1643
Copyright © 2003 PATCO Construction, Inc. All Rights Reserved.

LOT 1 MORNING STAR
LANE
THE CALLA BUNGALOW CAPE



DATE:
AUG. 15, 2014
SCALE:
AS SHOWN
DRAWN BY:
PEL
JOB NO.:
4221
CHK'D BY:

SHEET:
1
OF



RIGHT ELEVATION
SCALE: 1/4" = 1'-0"

THESE DRAWINGS HAVE BEEN DEVELOPED BY PATCO CONSTRUCTION INC.
FOR THE TITLED SET ONLY, THE DRAWINGS ARE THE SOLE PROPERTY OF
PATCO CONSTRUCTION INC. AND THEY SHALL NOT BE USED, LENT, ALTERED,
OR REPRODUCED WITHOUT WRITTEN CONSENT OF PATCO CONSTRUCTION.

Wednesday, August 13, 2014 1:16 PM

REVISIONS:

PATCO
CONSTRUCTION, INC.

1293 MAINE ST. SANFORD, ME. 04073 - (207) 324-5574 FAX (207) 324-1643
Copyright © 2003 PATCO Construction, Inc. All Rights Reserved.

LOT 1 MORNING STAR


LANE

THE CALLA BUNGALOW CAPE



DATE:
AUG. 15, 2014
SCALE:
AS SHOWN
DRAWN BY:
PEL
JOB NO.:
4221
CHKD BY:

SHEET:
2
OF

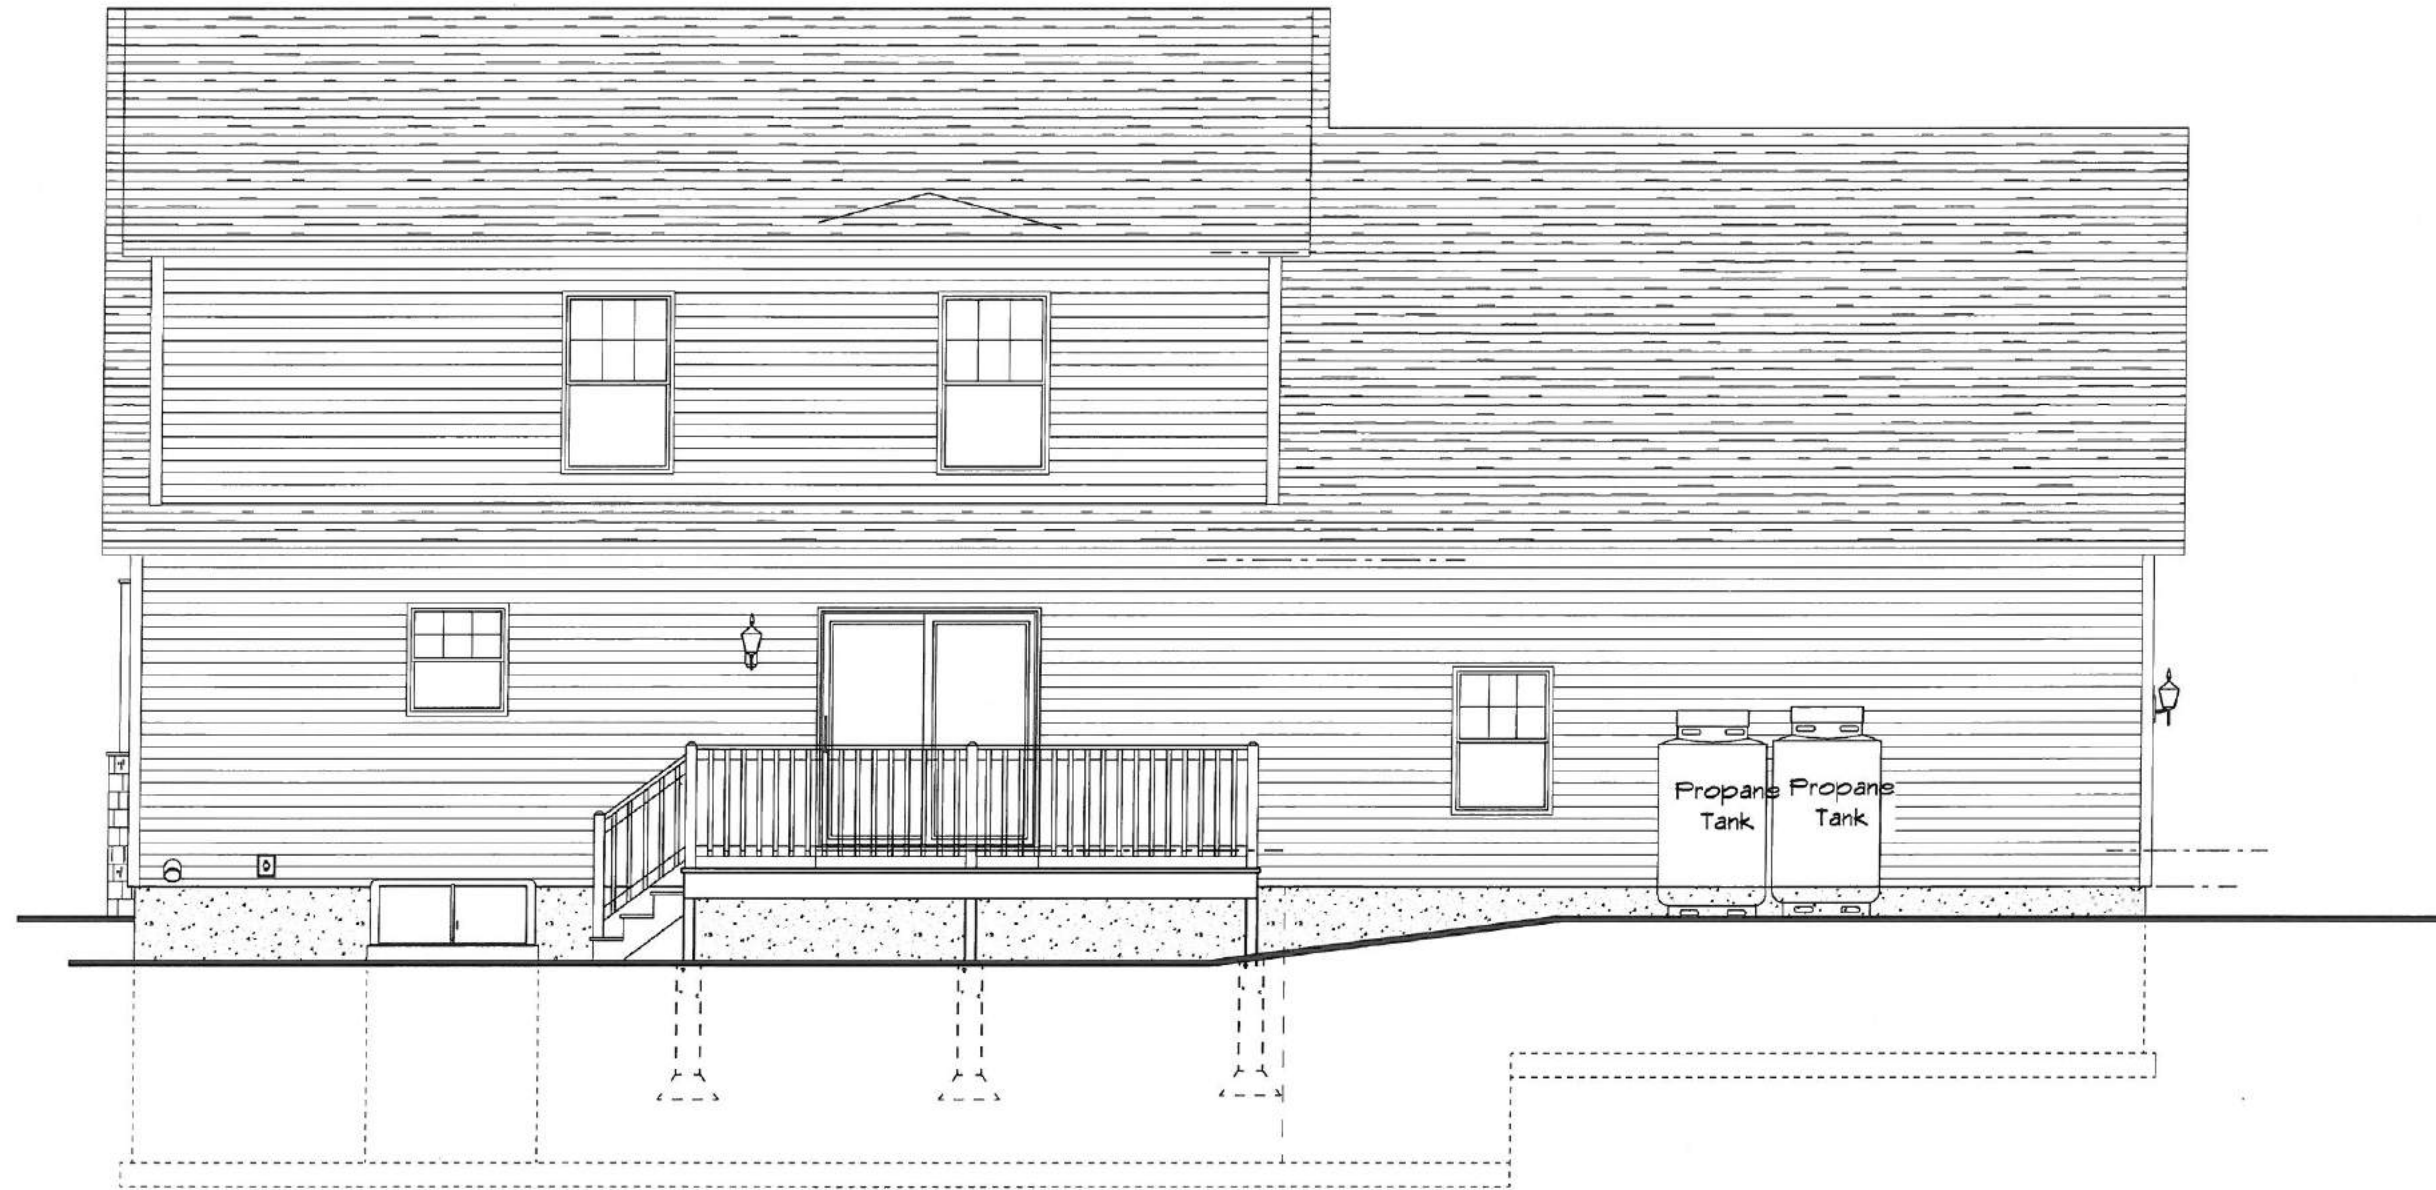

REAR ELEVATION
SCALE: 3/16" = 1'-0"

THESE DRAWINGS HAVE BEEN DEVELOPED BY PATCO CONSTRUCTION INC. FOR THE TITLED SET ONLY, THE DRAWINGS ARE THE SOLE PROPERTY OF PATCO CONSTRUCTION INC. AND THEY SHALL NOT BE USED, LENT, ALTERED, OR REPRODUCED WITHOUT WRITTEN CONSENT OF PATCO CONSTRUCTION.

Wednesday, August 13, 2014 01:18 PM

REVISIONS:

PATCO
CONSTRUCTION, INC.

1293 MAINE ST. SANFORD, ME. 04073 - (207) 324-5574 FAX (207) 324-1643
Copyright © 2003 PATCO Construction, Inc. All Rights Reserved.

LOT 1 MORNING STAR
LANE
THE CALLA BUNGALOW CAPE



DATE:
AUG. 15, 2014
SCALE:
AS SHOWN
DRAWN BY:
PEL
JOB NO.:
4221
CH'KD BY:

SHEET:

3
OF



LEFT ELEVATION
SCALE: 1/4" = 1'-0"

THESE DRAWINGS HAVE BEEN DEVELOPED BY PATCO CONSTRUCTION INC. FOR THE TITLED SET ONLY, THE DRAWINGS ARE THE SOLE PROPERTY OF PATCO CONSTRUCTION INC. AND THEY SHALL NOT BE USED, LENT, ALTERED, OR REPRODUCED WITHOUT WRITTEN CONSENT OF PATCO CONSTRUCTION.

Wednesday, August 13, 2014 1:18 PM

REVISIONS:

PATCO
CONSTRUCTION, INC.

1293 MAINE ST. SANFORD, ME. 04073 - (207) 324-5574 FAX (207) 324-1643
Copyright © 2003 PATCO Construction, Inc. All Rights Reserved.

LOT 1 MORNING STAR
LANE
THE CALLA BUNGALOW CAPE



DATE:
AUG. 15, 2014
SCALE:
AS SHOWN
DRAWN BY:
FEL
JOB NO.:
4221
CHKD BY:

SHEET:

4
OF

2X6 BOX HEADER
NTS

SINGLE 2X6 HEADER
NTS

3-2X8 HEADER W/ FILLER
NTS


VERSALAMB BEAM
NTS

A


B

C

D

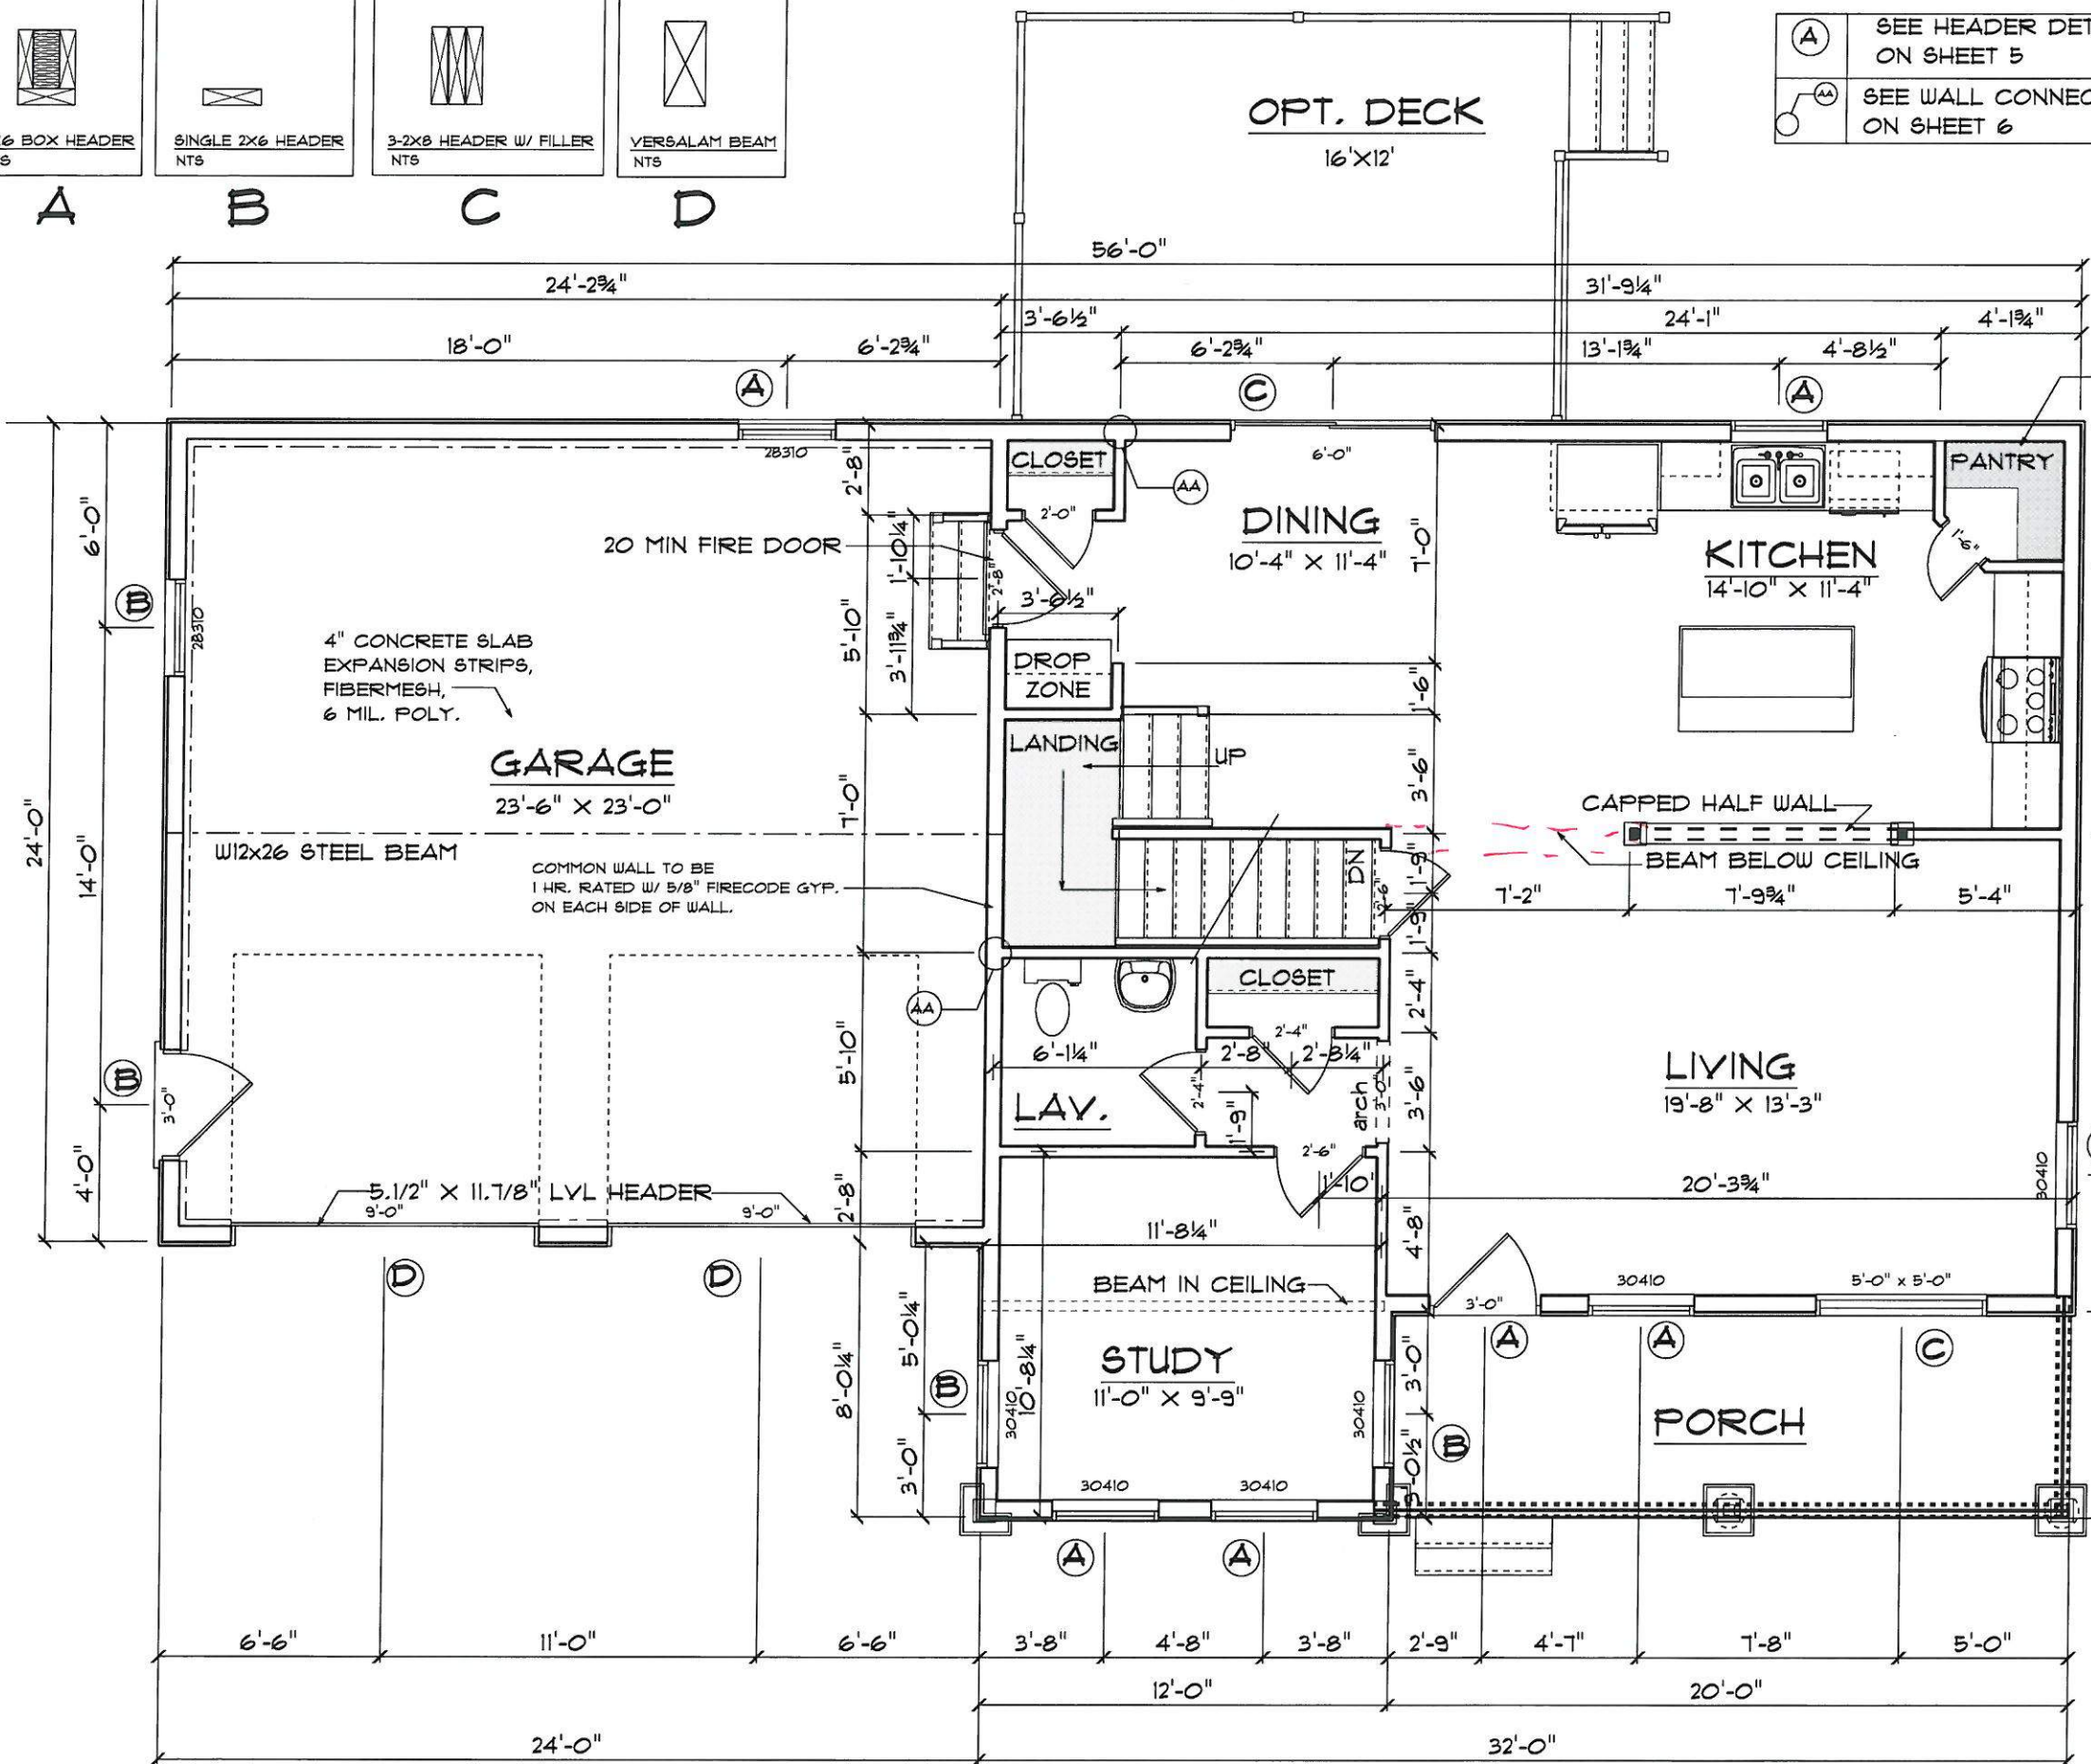

SEE DETAIL

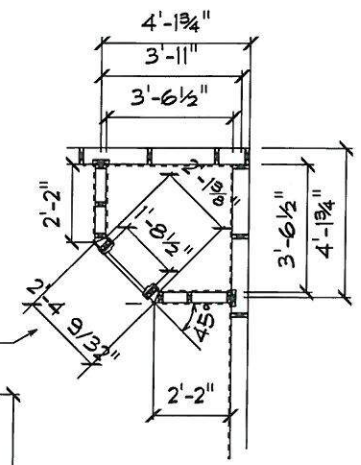

PANTRY WALL DETAIL
SCALE: 3/16" = 1'-0"

THESE DRAWINGS HAVE BEEN DEVELOPED BY
PATCO CONSTRUCTION INC.
FOR THE TITLED SET ONLY, THE DRAWINGS ARE
THE SOLE PROPERTY OF
PATCO CONSTRUCTION INC. AND THEY SHALL NOT
BE USED, LENT, ALTERED,
OR REPRODUCED WITHOUT WRITTEN CONSENT OF
PATCO CONSTRUCTION.

FIRST FLOOR PLAN
SCALE: 3/16" = 1'-0"

REVISIONS:

PATCO
CONSTRUCTION, INC.

1293 MAINE ST. SANFORD, ME 04073 - (207)324-5574 FAX (207)324-1643
Copyright © 2003 PATCO Construction, Inc. All Rights Reserved.

LOT 1 MORNING STAR
LANE
THE CALLA BUNGALOW CAPE

WOMAN-CENTRIC BUILDERS

DATE:
AUG. 15, 2014

SCALE:
AS SHOWN

DRAWN BY:
PEL

JOB NO.:
4221

CHK'D BY:

SHEET:
5
OF



DATE:
AUG. 15, 2014
SCALE:
AS SHOWN
DRAWN BY:
PEL
JOB NO.:
4221
CHK'D BY:

SHEET:


6
OF

SECOND FLOOR PLAN

SCALE: 3/16" = 1'-0"

OPENING SCHEDULE		
PRODUCT CODE	COUNT	R.O. SIZE
24210	1	R.O. 2'-6" x 3'-1 1/4"
28210	1	R.O. 2'-10" x 3'-1 1/4 1/2"
28310	2	R.O. 2'-10" x 4'-1 1/4"
30410	8	R.O. 3'-2" x 5'-1 1/4"
243	1	R.O. 2'-5" x 2'-11 3/4"
55-FW	1	R.O. 5'-0" x 4'-11 3/4"
284	4	R.O. 2'-8" x 3'-11 1/4"


LOCATION	R.O. SIZE	TYPE
GARAGE SIDE DOOR	R.O. 3'-2 1/2" x 6'-10 1/2"	3 LITE MHD 6.9/16 JAMB
FRONT DOOR	R.O. 3'-2 1/2" x 6'-10 1/2"	CRAFTSMAN DOOR 6.9/16"
20 MIN FIRE DOOR	R.O. 2'-10 1/2" x 6'-10 1/2"	6-PANEL MHD 6.9/16" JAMB
GLASS DOOR	R.O. 6'-0 1/4" x 6'-8 1/4"	HARVEY SLIDING GLASS DOOR
BASEMENT DOOR	R.O. 3'-2 1/2" x 6'-10 1/2"	6-PANEL MHD 4.9/16 JAMB

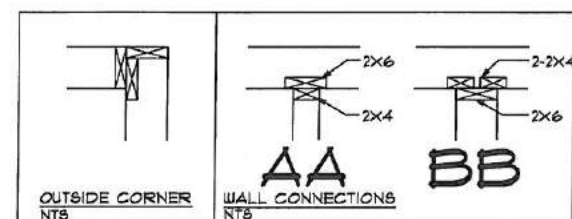

THESE DRAWINGS HAVE BEEN DEVELOPED BY PATCO CONSTRUCTION INC. FOR THE TITLED SET ONLY, THE DRAWINGS ARE THE SOLE PROPERTY OF PATCO CONSTRUCTION INC. AND THEY SHALL NOT BE USED, LENT, ALTERED, OR REPRODUCED WITHOUT WRITTEN CONSENT OF PATCO CONSTRUCTION.

Thursday, August 21, 2014

10:34 AM

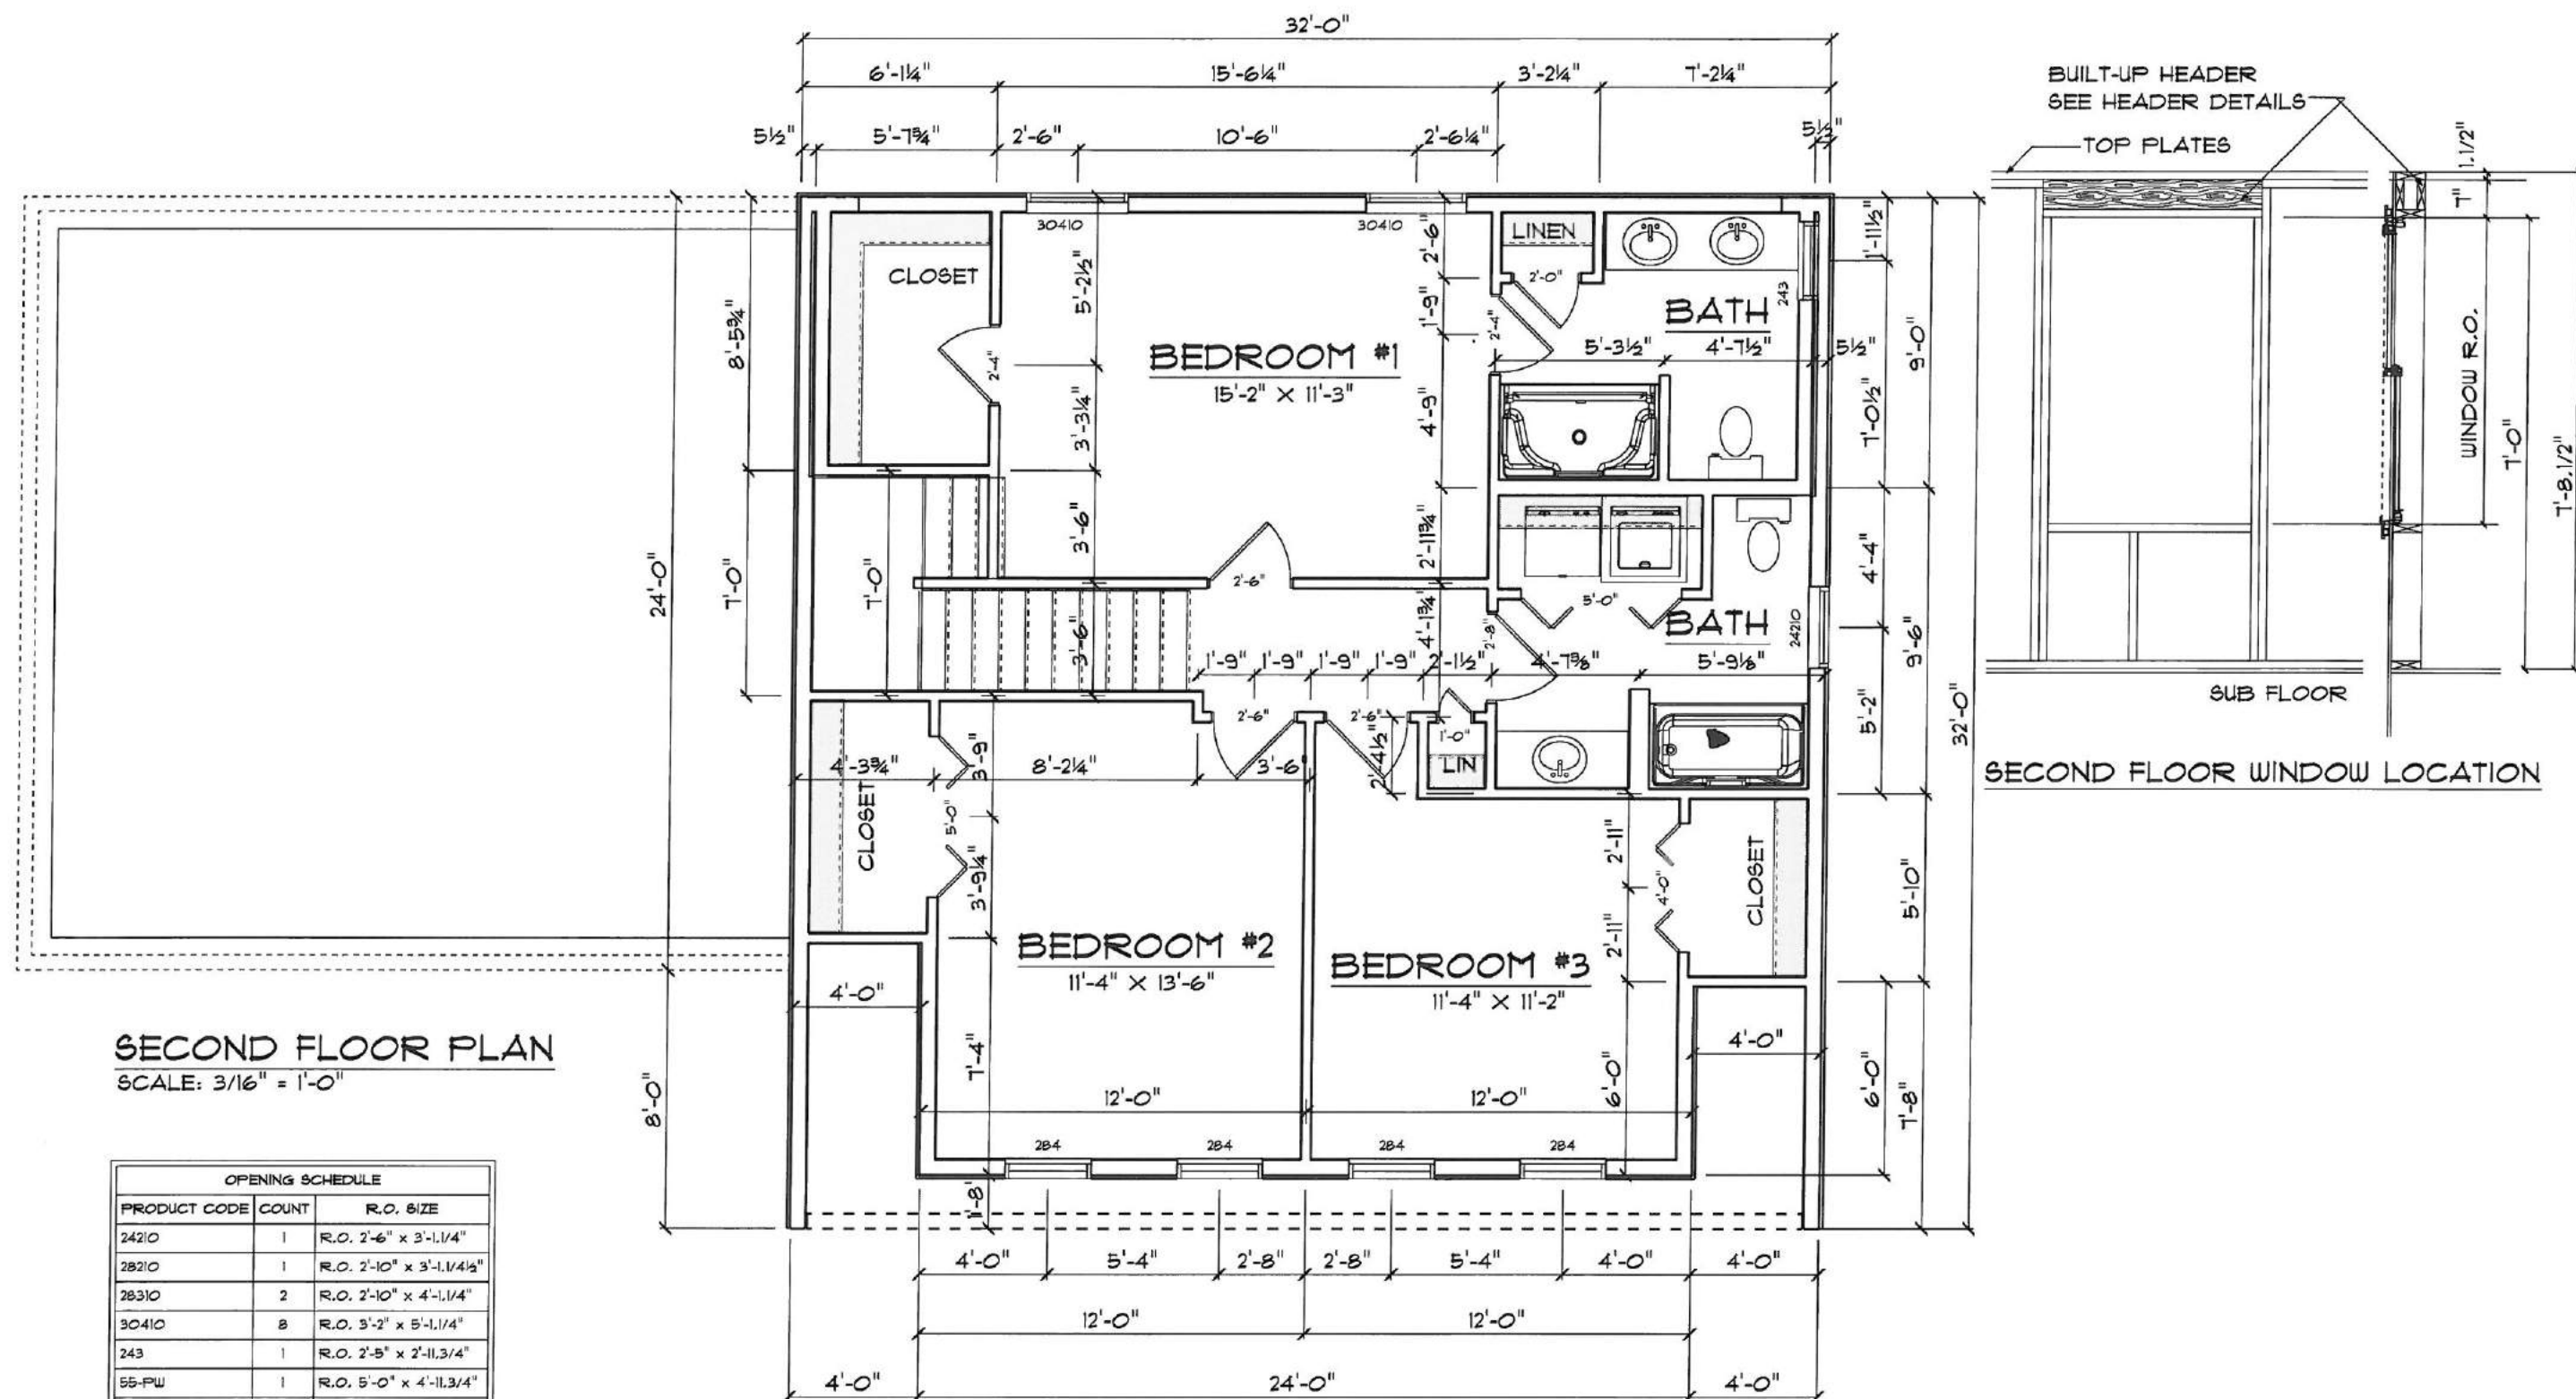

THESE DRAWINGS HAVE BEEN DEVELOPED BY PATCO CONSTRUCTION INC. FOR THE TITLED SET ONLY, THE DRAWINGS ARE THE SOLE PROPERTY OF PATCO CONSTRUCTION INC. AND THEY SHALL NOT BE USED, LENT, ALTERED, OR REPRODUCED WITHOUT WRITTEN CONSENT OF PATCO CONSTRUCTION.

NOTE:
ALL REBAR PER
IRC 2009 CODES

REVISIONS:



PATCO
CONSTRUCTION, INC.

Copyright © 2003 PATCO Construction, Inc. All Rights Reserved.

LOT 1 MORNING STAR
LANE
THE CALLA BUNGALOW CAPE

DATE:
AUG. 15, 2014

SCALE:
AS SHOWN


DRAWN BY:
PEL

JOB NO.:
4221

CH'KD BY:

SHEET:


7
OF

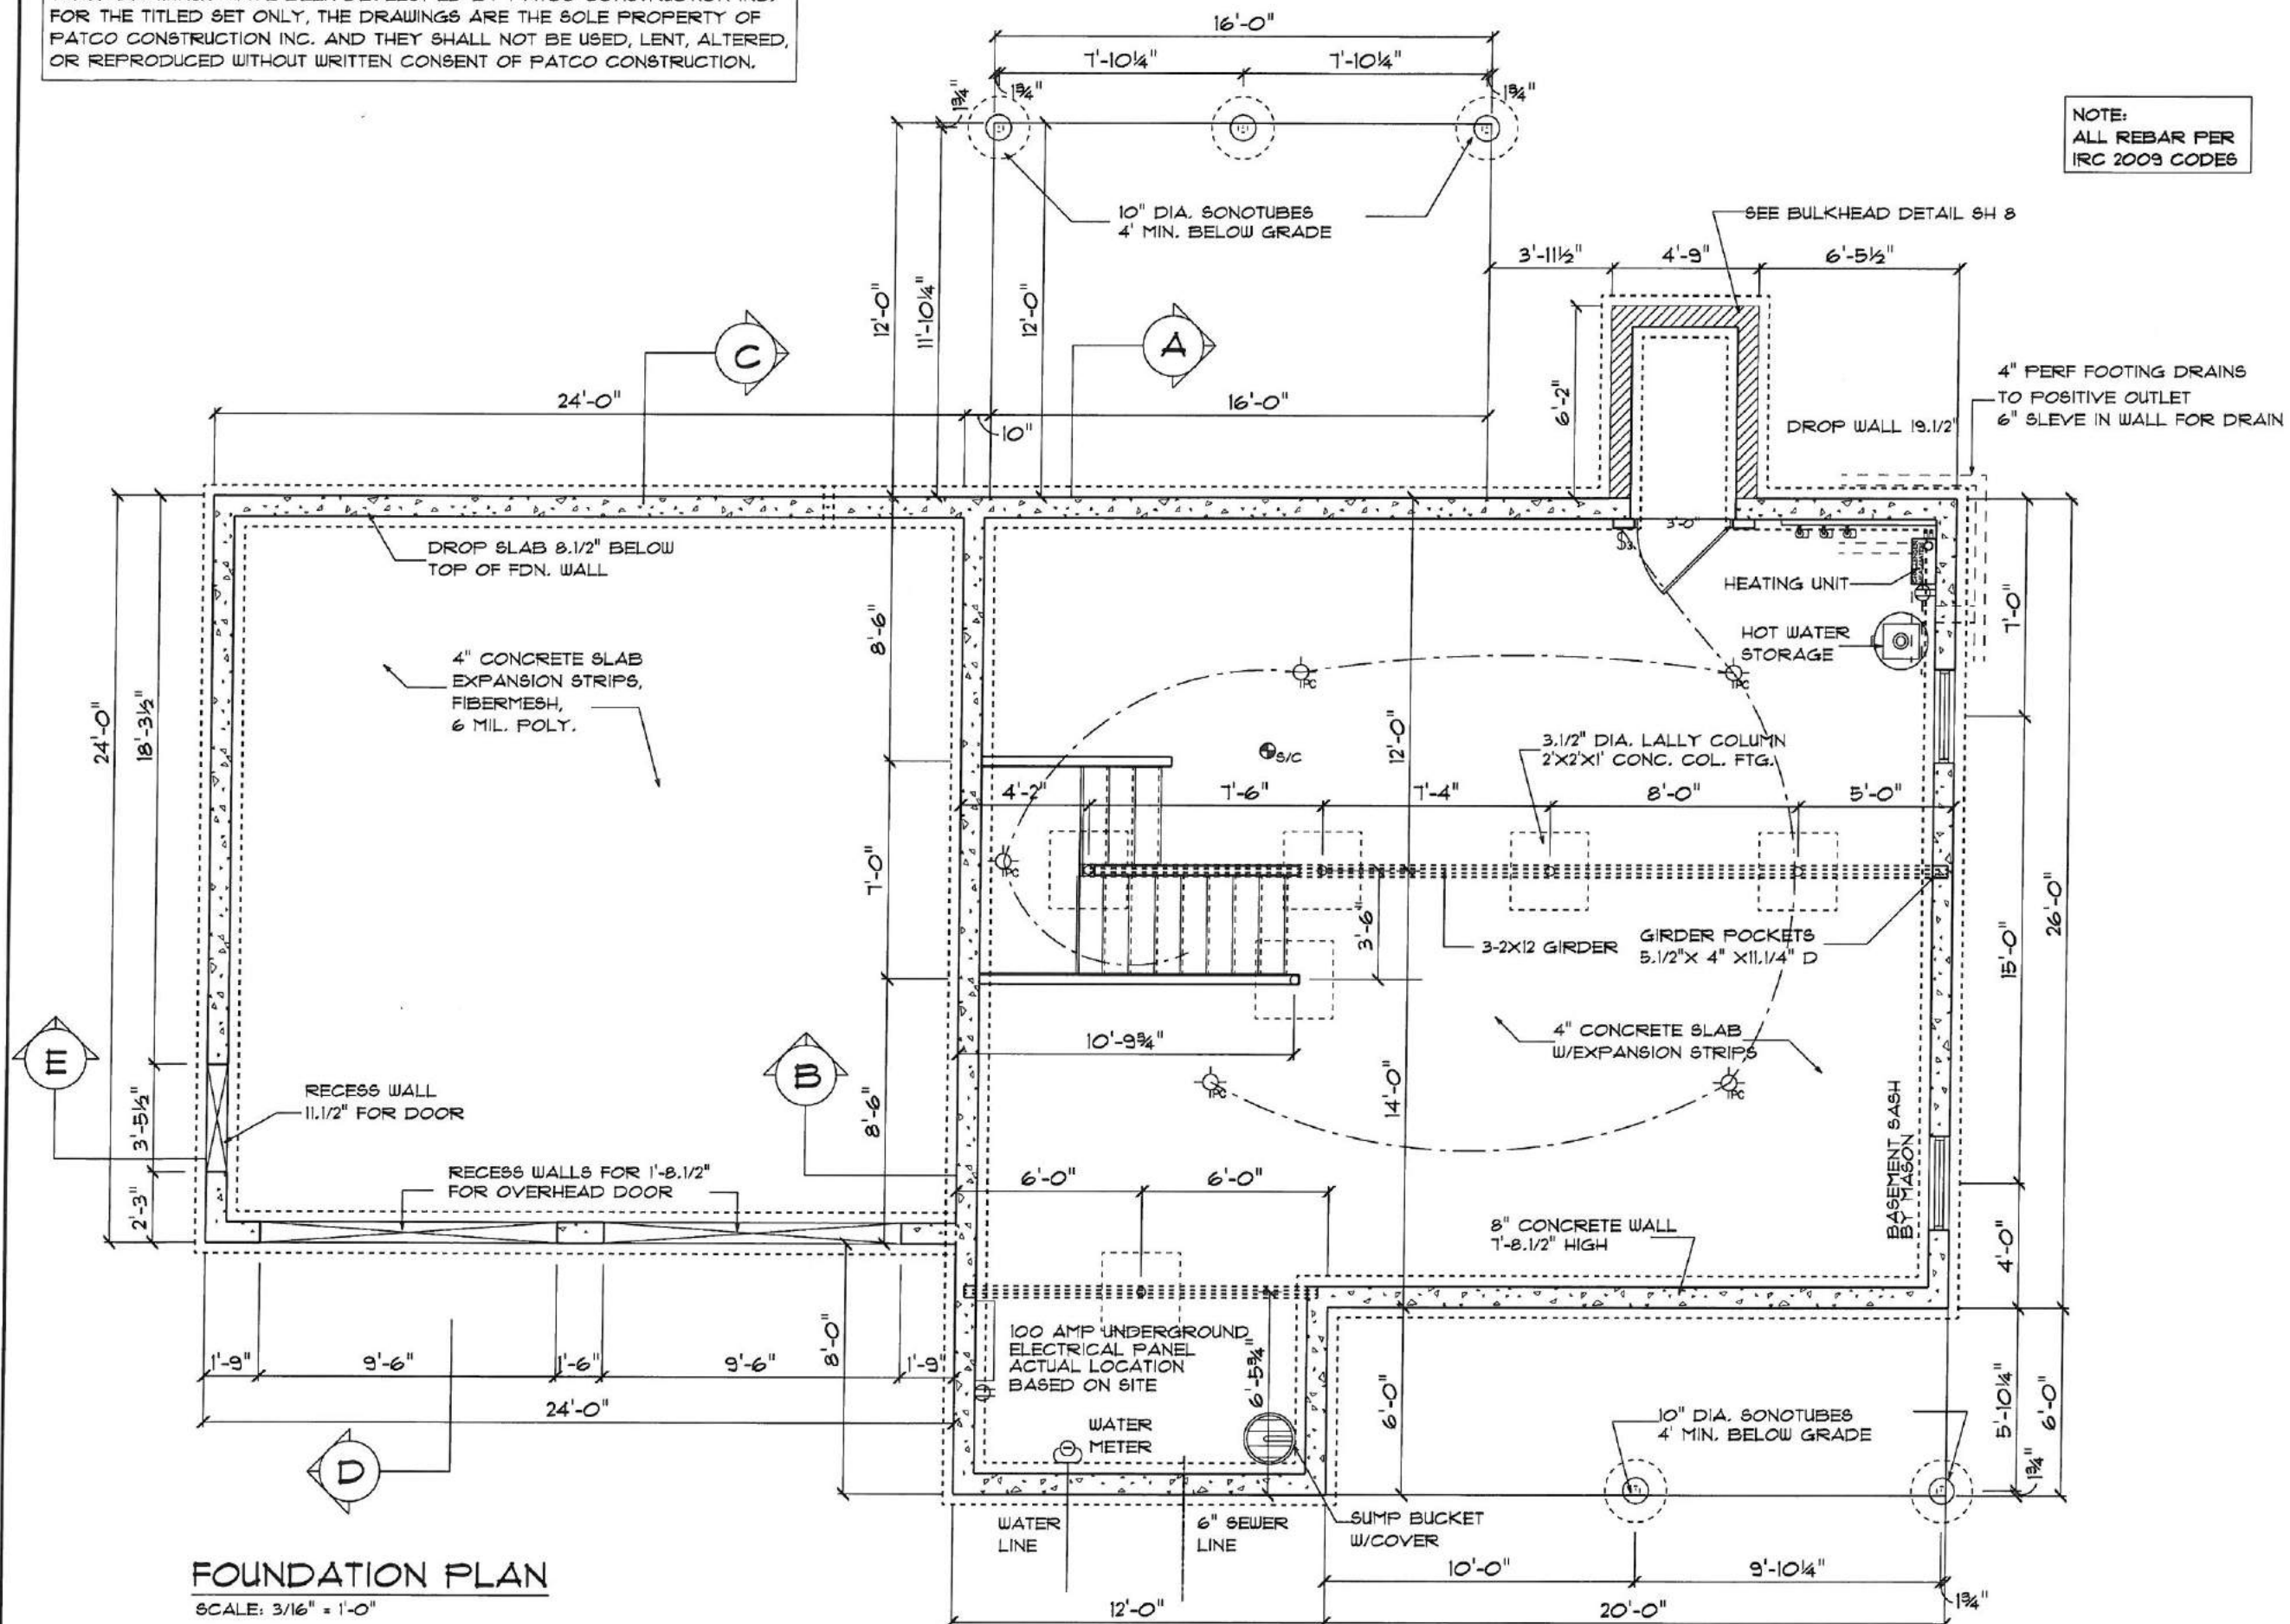

FOUNDATION PLAN
SCALE: 3/16" = 1'-0"


Thursday, August 21, 2014

03:52 PM

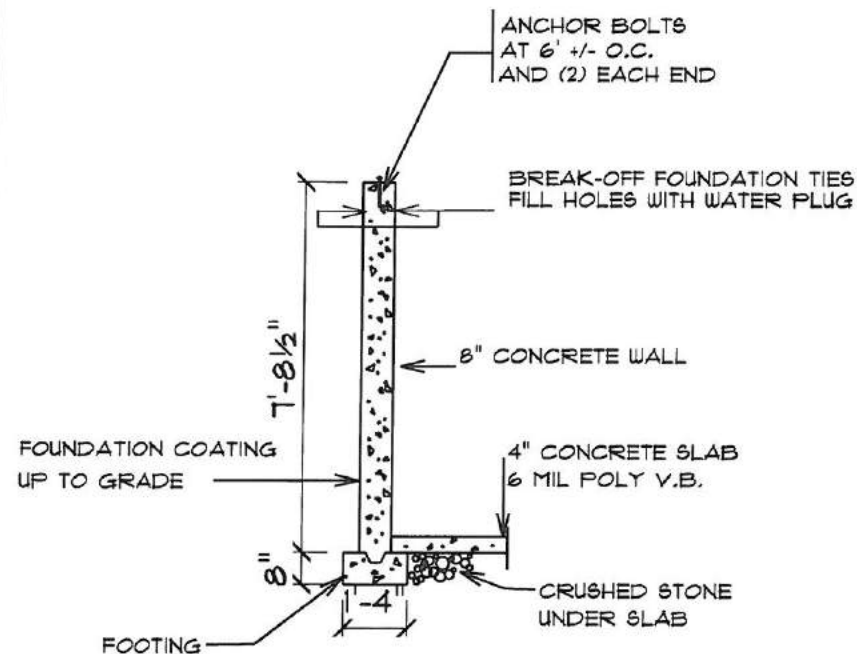


DETAIL "A"

SCALE 1/4" = 1'-0"

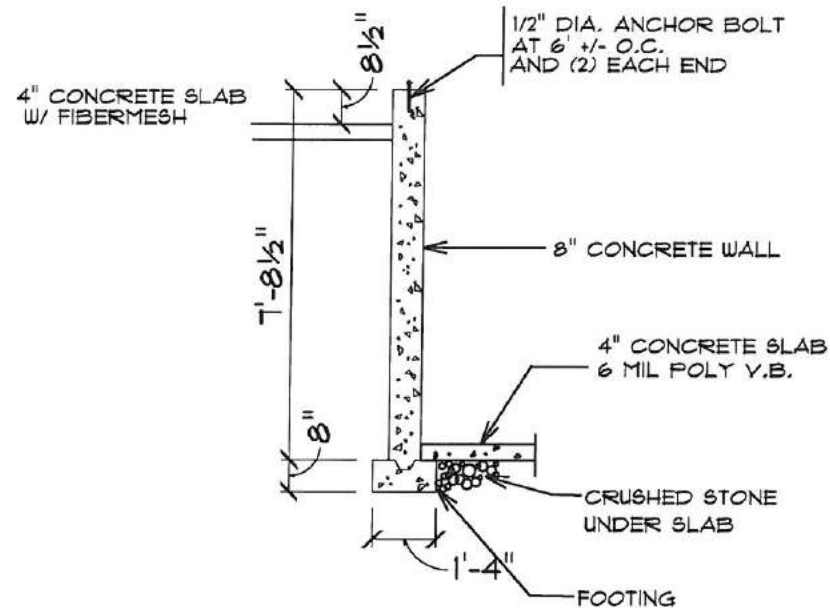

DETAIL "B"


SCALE 1/4" = 1'-0"

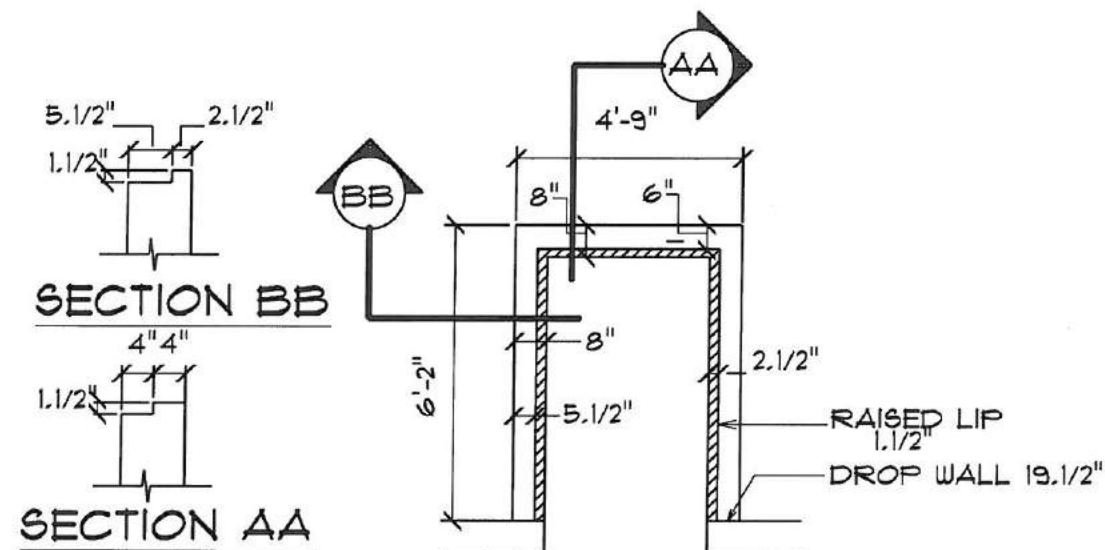

BULKHEAD DETAIL


NO SCALE

NOTE:
ALL REBAR PER
IRC 2009 CODES

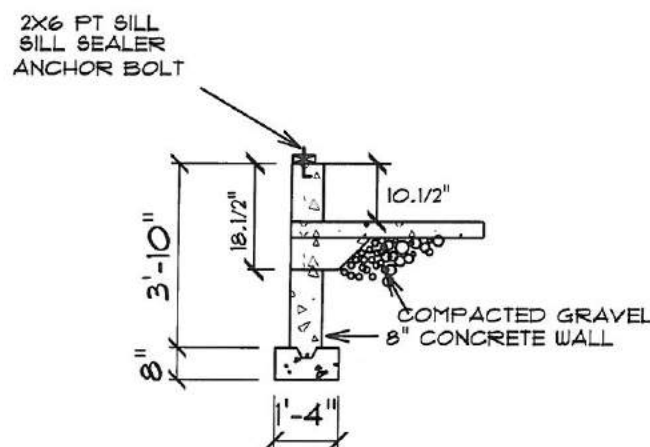


DETAIL "D"

SCALE 1/4" = 1'-0"

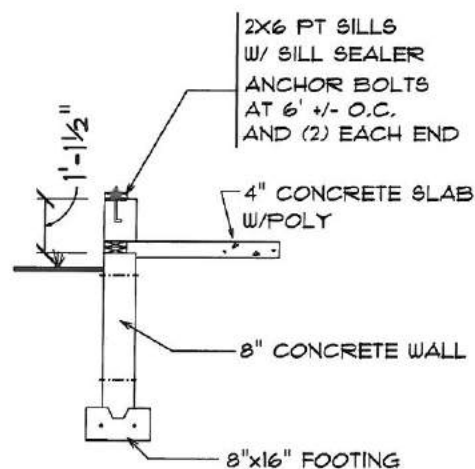


DETAIL "E"

SCALE 1/4" = 1'-0"

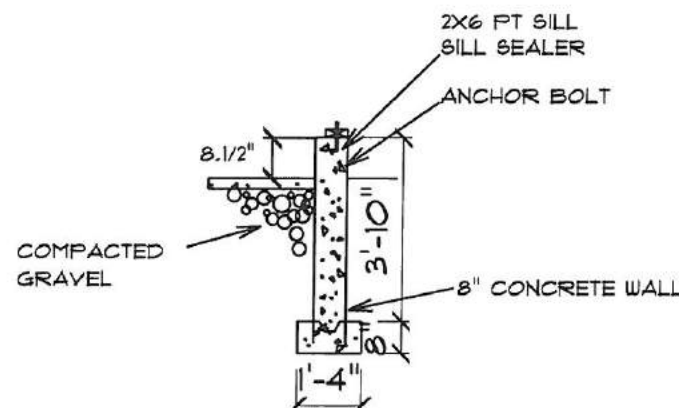

DETAIL "C"

SCALE 1/4" = 1'-0"

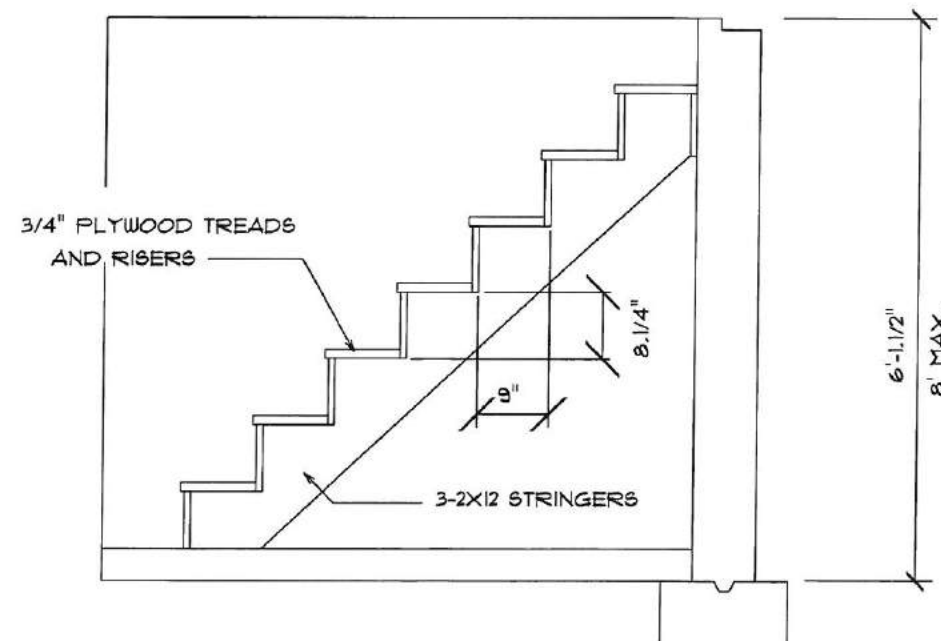

BULKHEAD CD-3

THESE DRAWINGS HAVE BEEN DEVELOPED BY PATCO CONSTRUCTION INC. FOR THE TITLED SET ONLY, THE DRAWINGS ARE THE SOLE PROPERTY OF PATCO CONSTRUCTION INC. AND THEY SHALL NOT BE USED, LENT, ALTERED, OR REPRODUCED WITHOUT WRITTEN CONSENT OF PATCO CONSTRUCTION.

Thursday, August 21, 2014

03:48 PM

REVISIONS:

PATCO
CONSTRUCTION, INC.



1299 MAINE ST. SANFORD, ME. 04078 - 12071324-5574 FAX 12071324-1643
Copyright © 2003 PATCO Construction, Inc. All Rights Reserved.


LOT 1 MORNING STAR
LANE
THE CALLA BUNGALOW CAPE



DATE:
AUG. 15, 2014
SCALE:
AS SHOWN
DRAWN BY:
PEL
JOB NO.:
4221
CHK'D BY:

SHEET:

8
OF

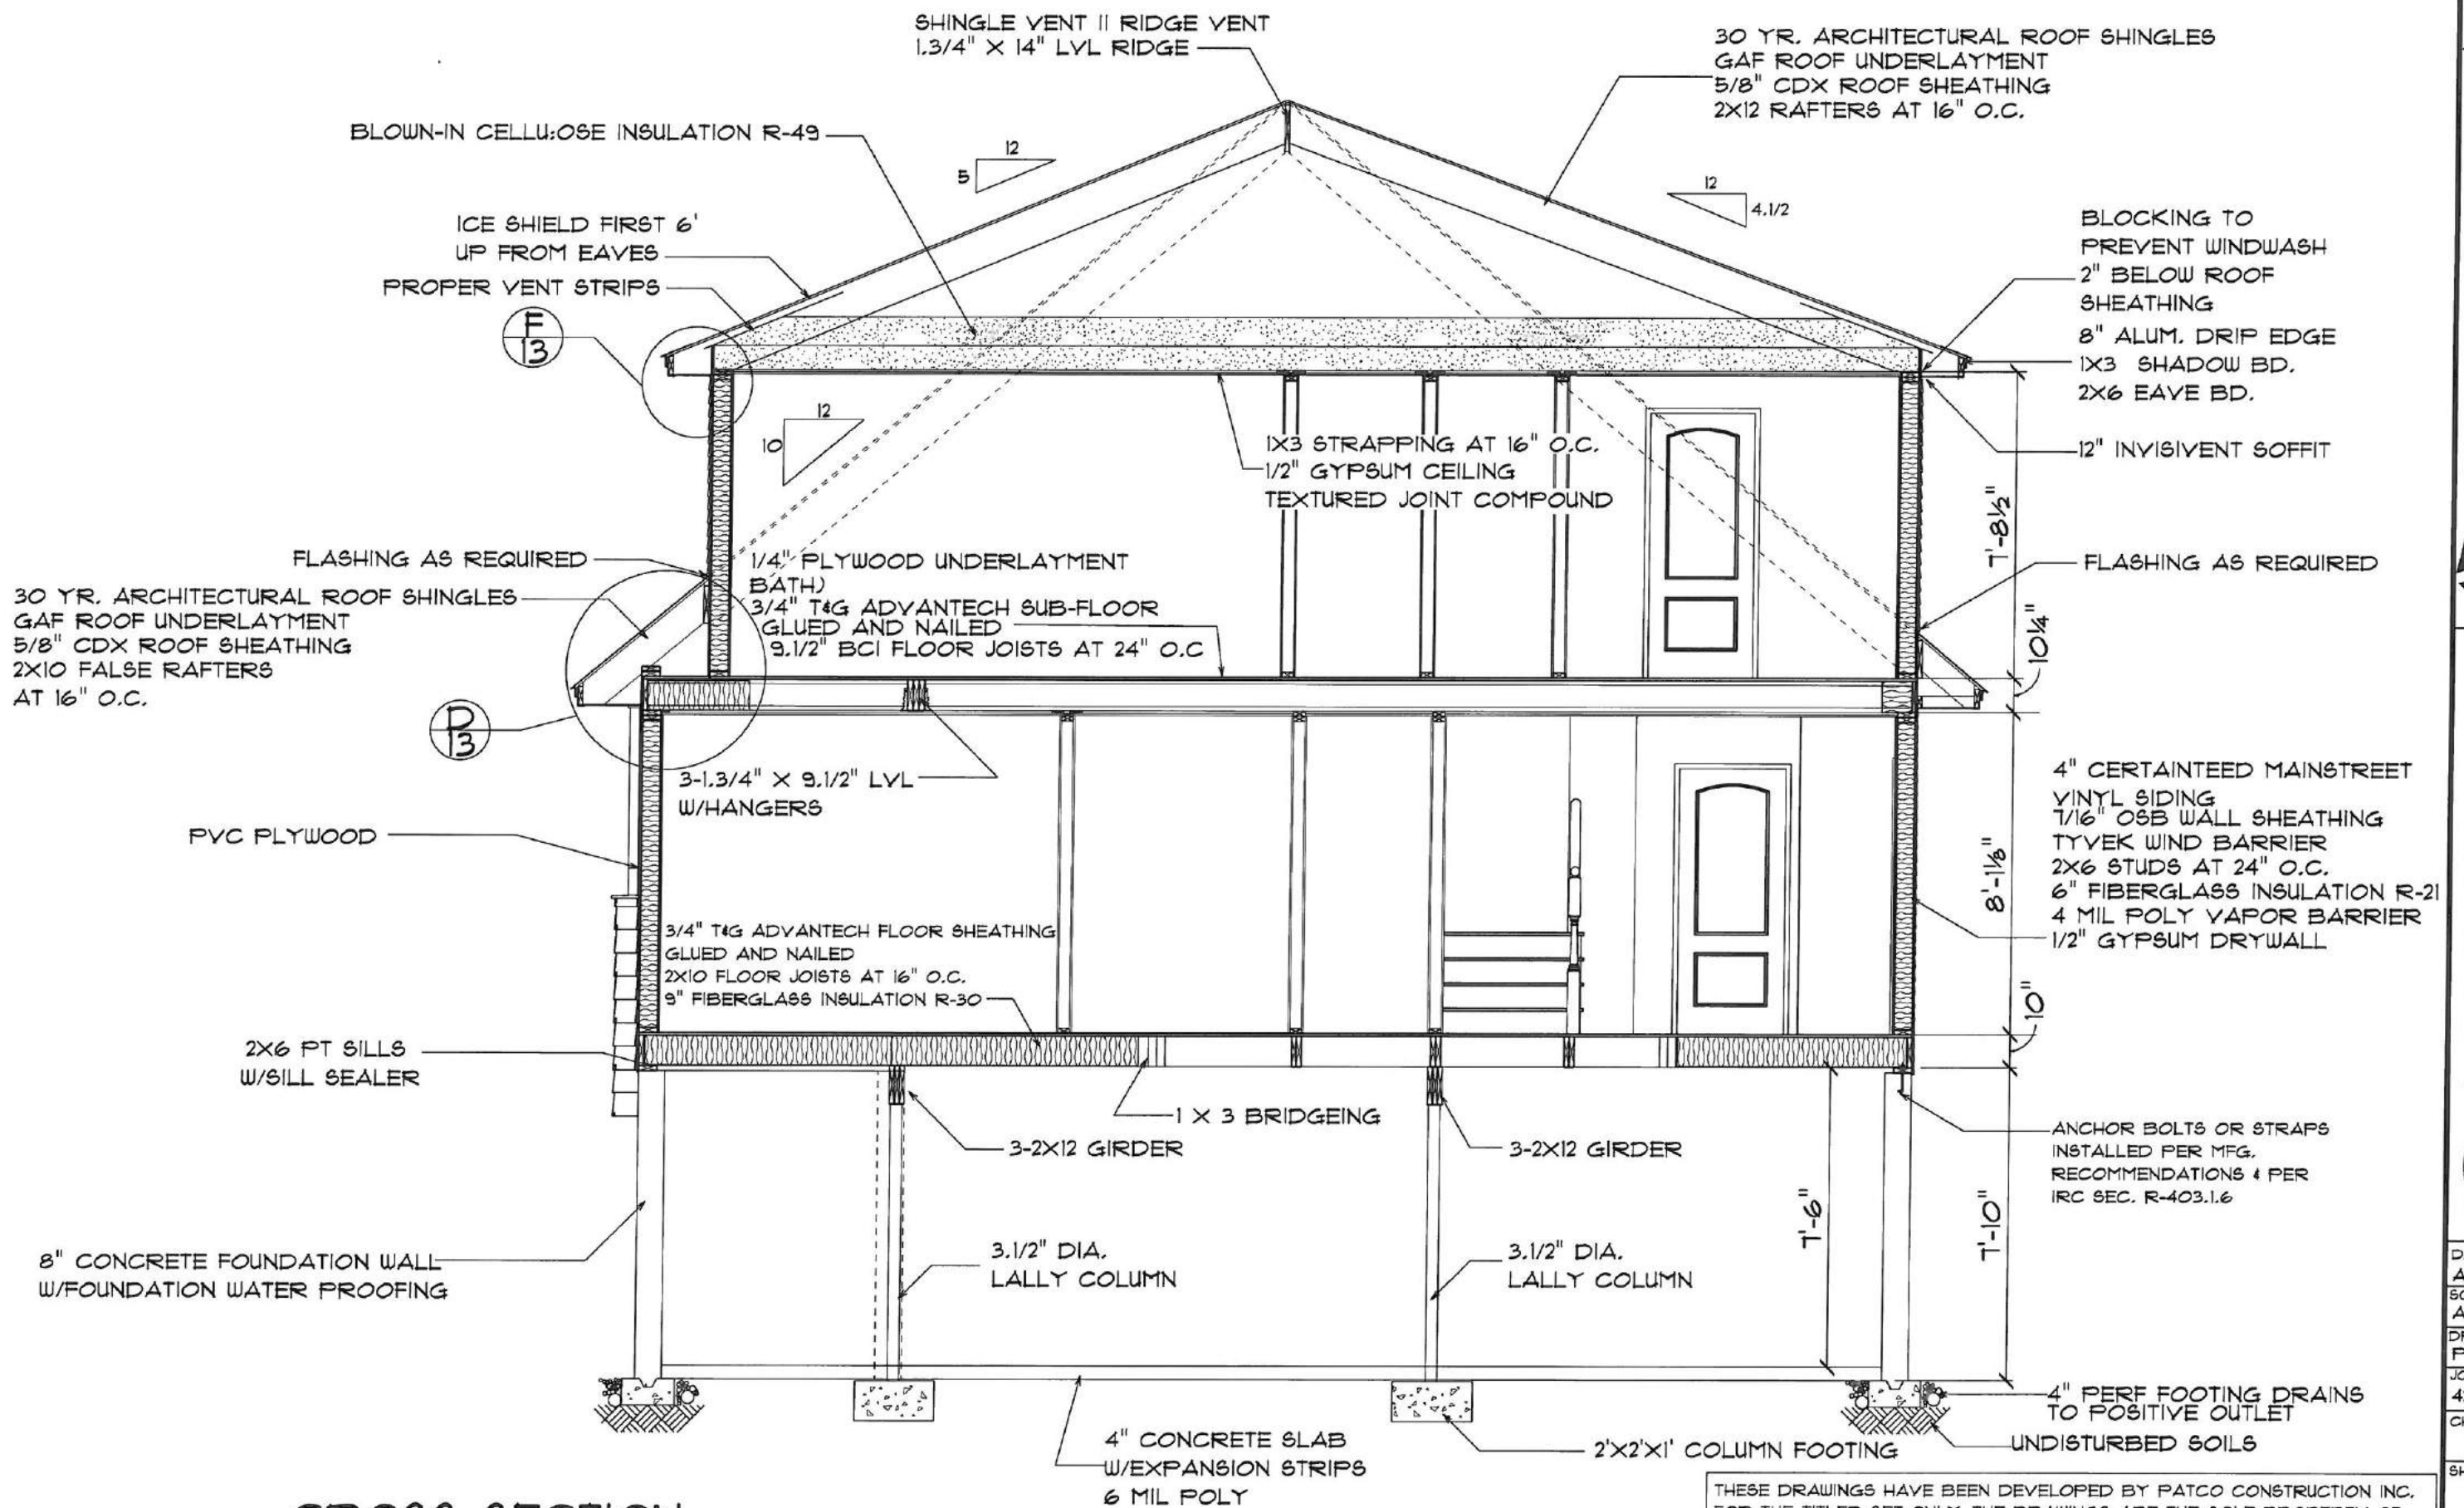


CROSS SECTION

SCALE: 1/4" = 1'-0"

THESE DRAWINGS HAVE BEEN DEVELOPED BY PATCO CONSTRUCTION INC.
FOR THE TITLED SET ONLY, THE DRAWINGS ARE THE SOLE PROPERTY OF
PATCO CONSTRUCTION INC. AND THEY SHALL NOT BE USED, LENT, ALTERED,
OR REPRODUCED WITHOUT WRITTEN CONSENT OF PATCO CONSTRUCTION.


Thursday, August 21, 2014

05:17 PM

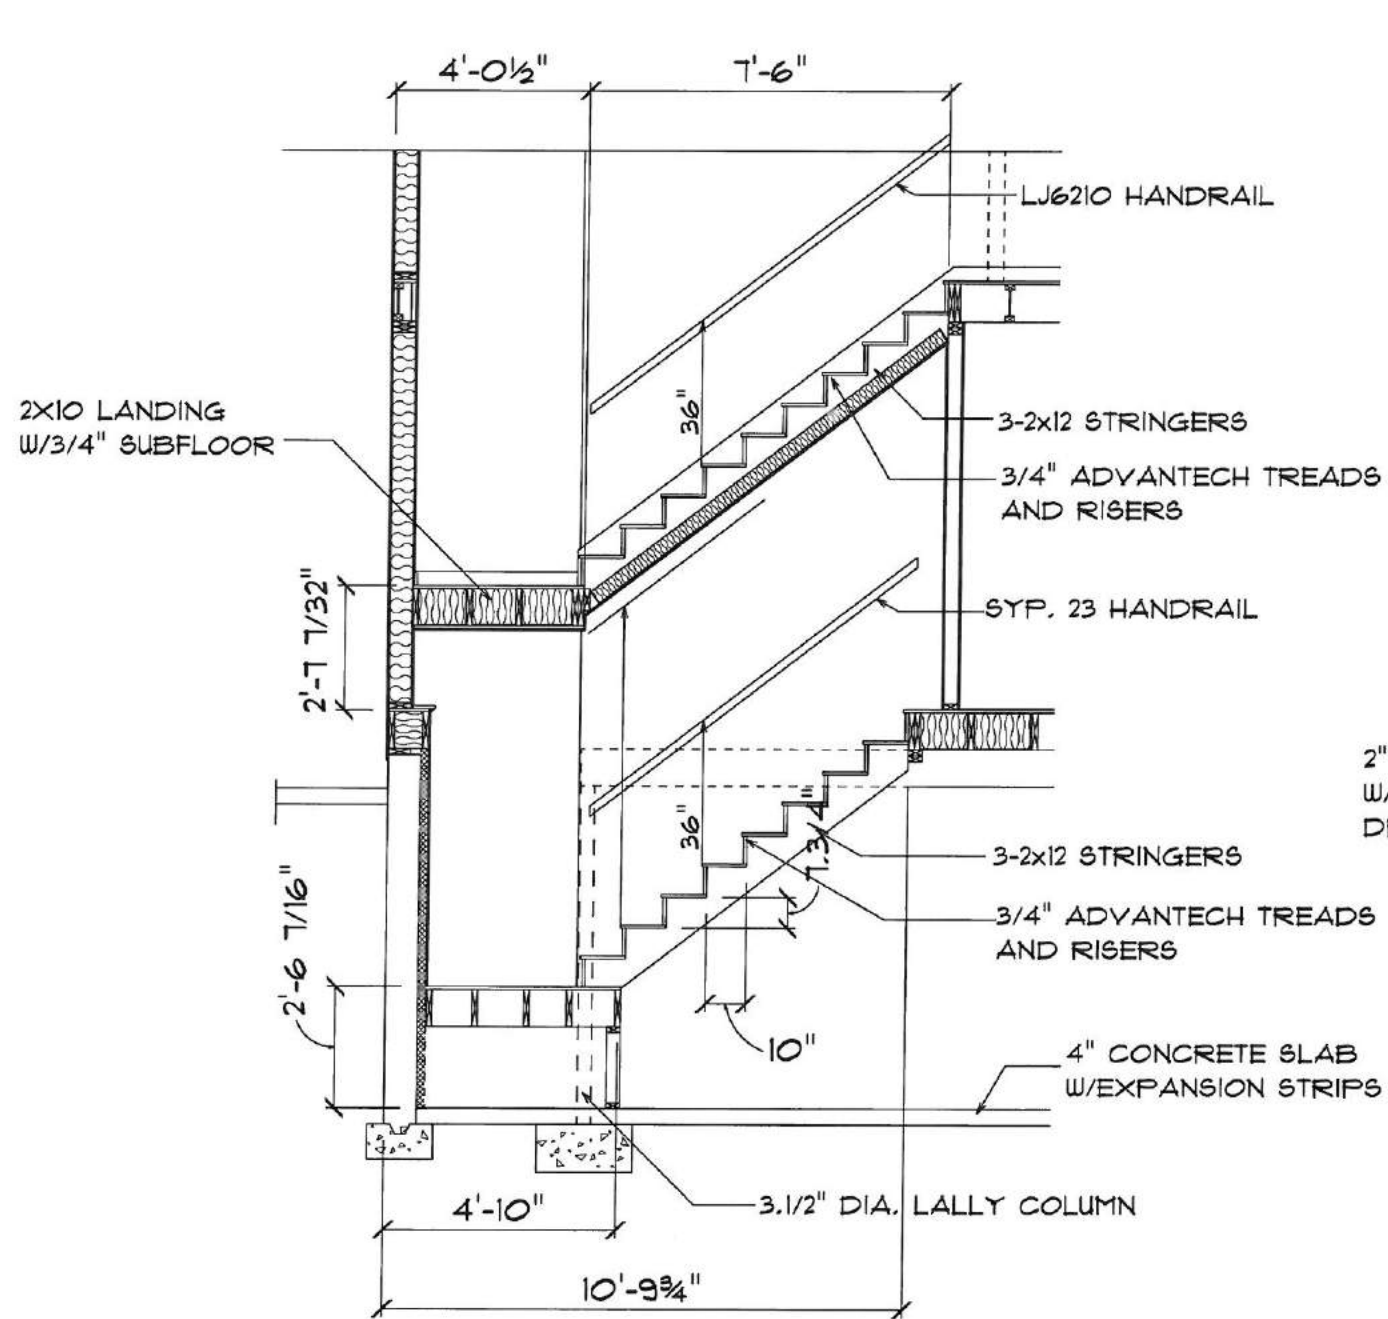

STAIR SECTION

SCALE: 1/4" = 1'-0"

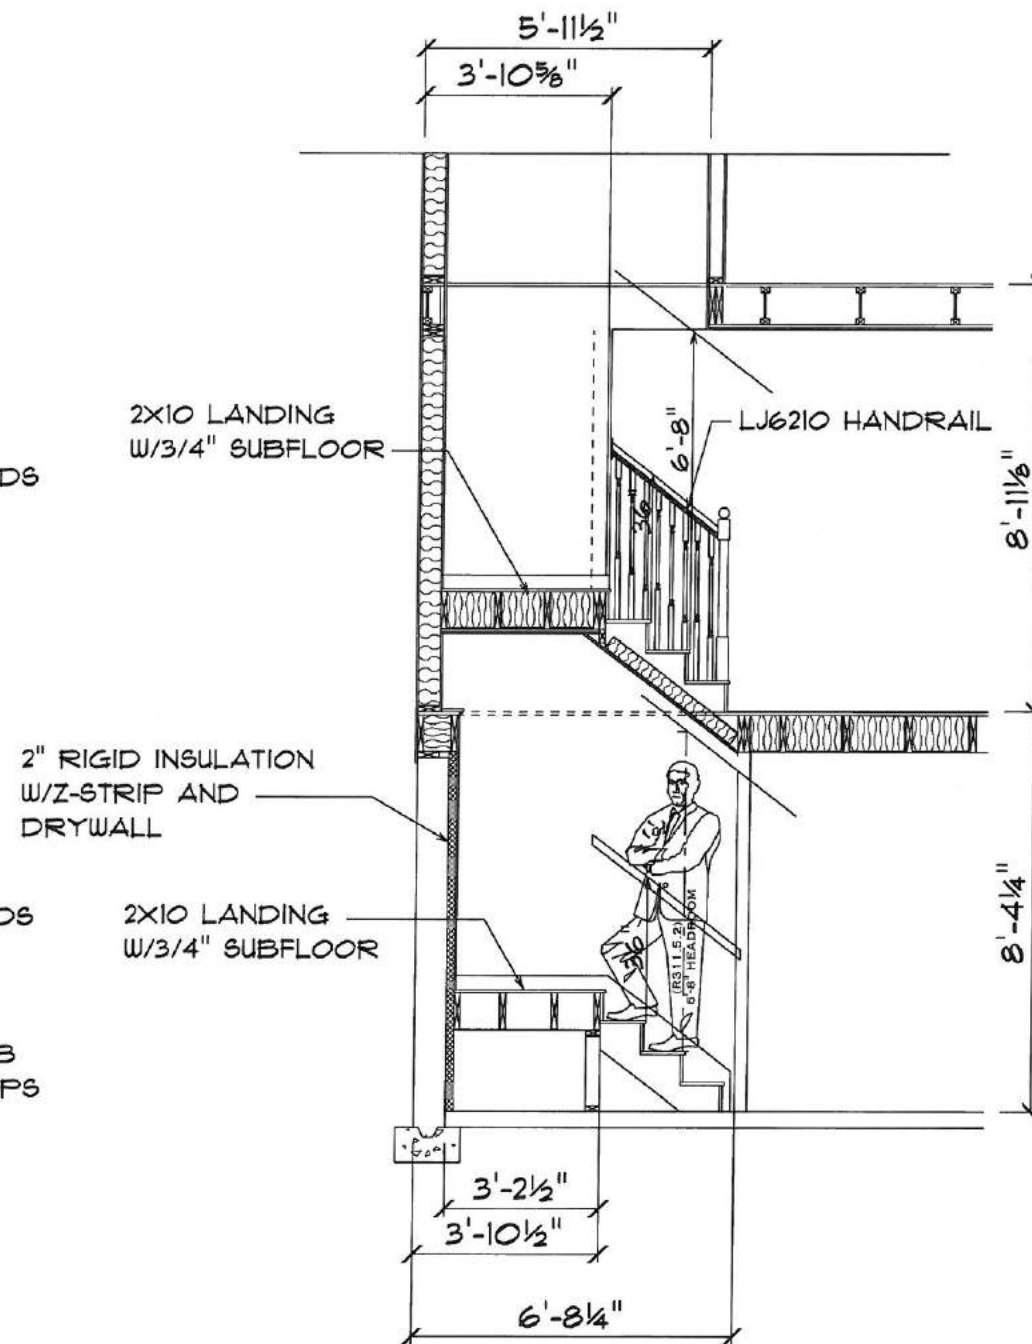

STAIR SECTION

SCALE: 1/4" = 1'-0"

THESE DRAWINGS HAVE BEEN DEVELOPED BY PATCO CONSTRUCTION INC.
FOR THE TITLED SET ONLY, THE DRAWINGS ARE THE SOLE PROPERTY OF
PATCO CONSTRUCTION INC. AND THEY SHALL NOT BE USED, LENT, ALTERED,
OR REPRODUCED WITHOUT WRITTEN CONSENT OF PATCO CONSTRUCTION.

Thursday, August 21, 2014

05:34 PM

REVISIONS:

PATCO
CONSTRUCTION, INC.



1293 MAINE ST. SANFORD, ME. 04073 - 12071324-5574 FAX 12071324-1643
Copyright © 2003 PATCO Construction, Inc. All Rights Reserved.

LOT 1 MORNING STAR

LANE

THE CALLA BUNGALOW CAPE



DATE:
AUG. 15, 2014
SCALE:
AS SHOWN
DRAWN BY:
FEL
JOB NO.:
4221
CHKD BY:

SHEET:

11
OF

REVISIONS:

PATCO
CONSTRUCTION, INC.


1293 MAINE ST. SANFORD, ME. 04073 - 12071324-5574 FAX 12071324-1643
Copyright © 2003 PATCO Construction, Inc. All Rights Reserved.

LOT 1 MORNING STAR
LANE
THE CALLA BUNGALOW CAPE




DATE:
AUG. 15, 2014
SCALE:
AS SHOWN
DRAWN BY:
PEL
JOB NO.:
4221
CHKD BY:

SHEET:
12
OF

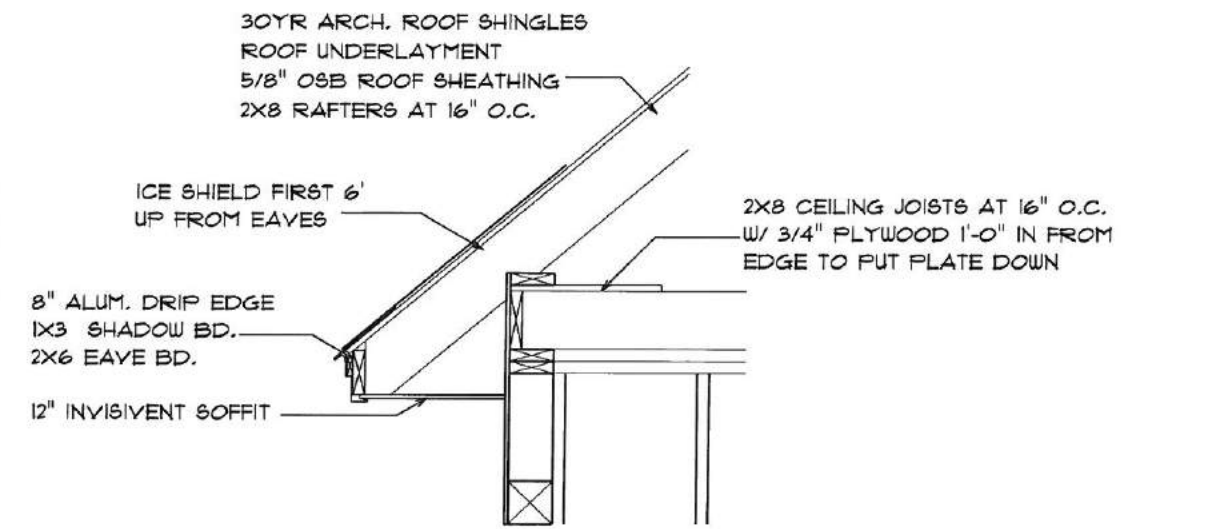

DETAIL "H"


SCALE: 1/4" = 1'-0"

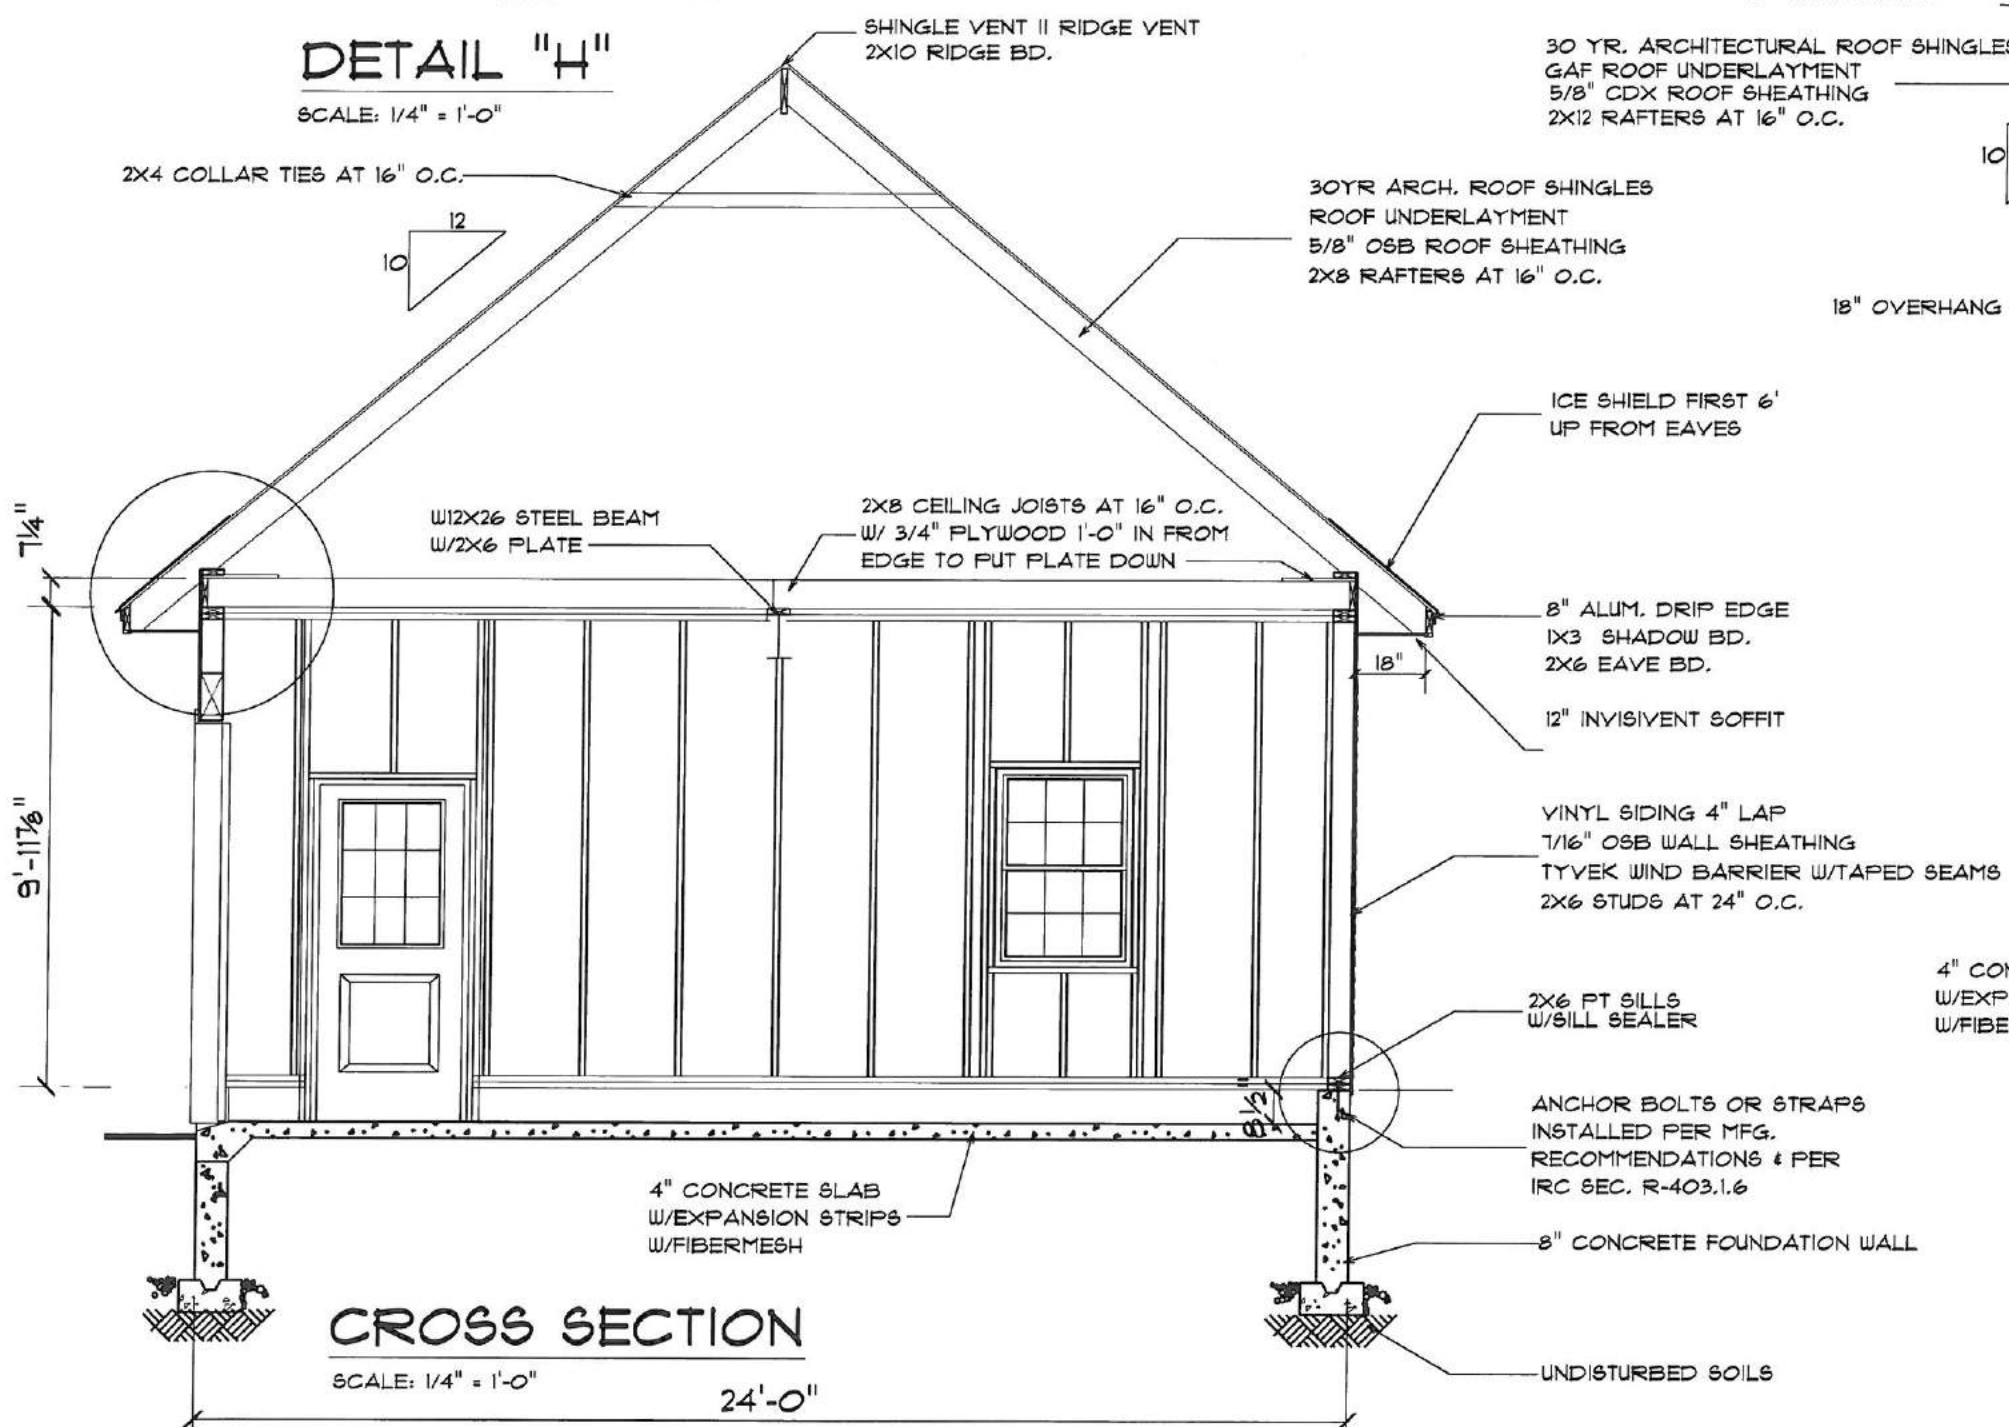

CROSS SECTION


SCALE: 1/4" = 1'-0"

24'-0"

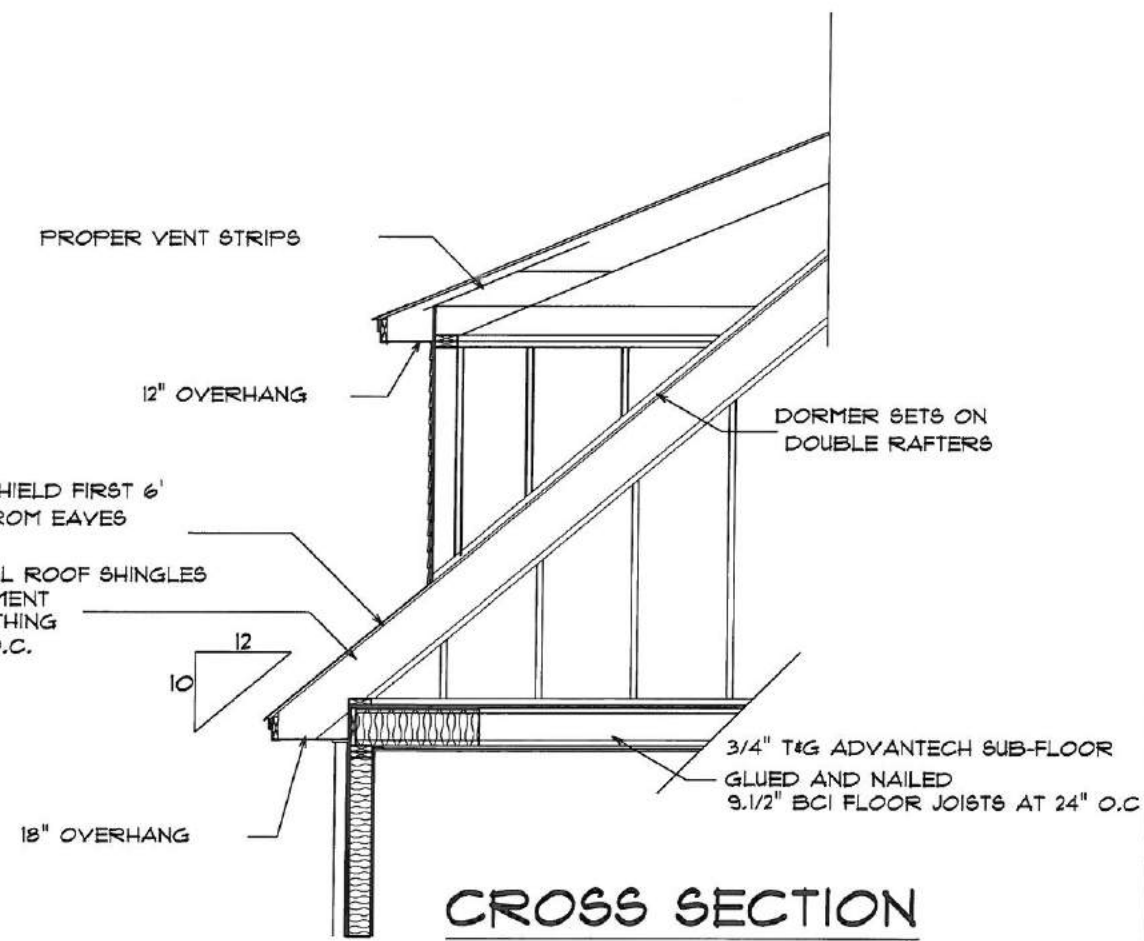

CROSS SECTION

SCALE: 1/4" = 1'-0"

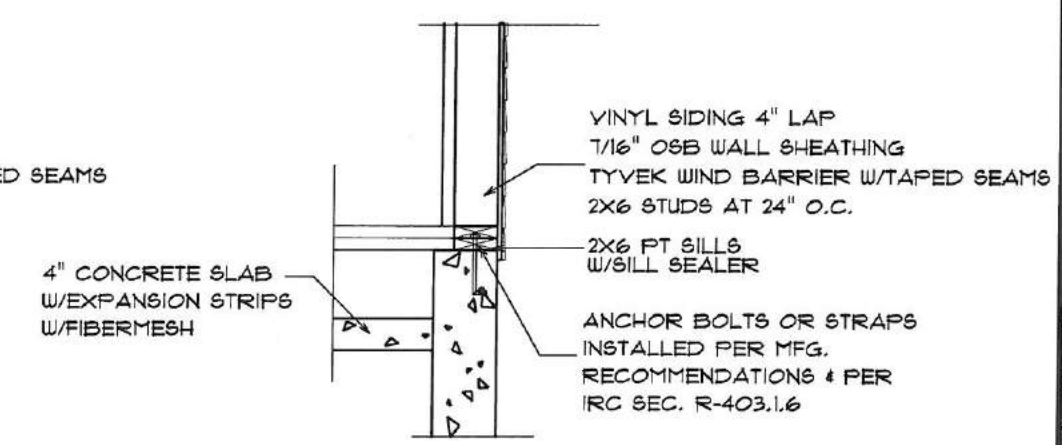


DETAIL "G"

SCALE: 1/4" = 1'-0"


THESE DRAWINGS HAVE BEEN DEVELOPED BY PATCO CONSTRUCTION INC. FOR THE TITLED SET ONLY, THE DRAWINGS ARE THE SOLE PROPERTY OF PATCO CONSTRUCTION INC. AND THEY SHALL NOT BE USED, LENT, ALTERED, OR REPRODUCED WITHOUT WRITTEN CONSENT OF PATCO CONSTRUCTION.

Thursday, August 21, 2014


05:42 PM

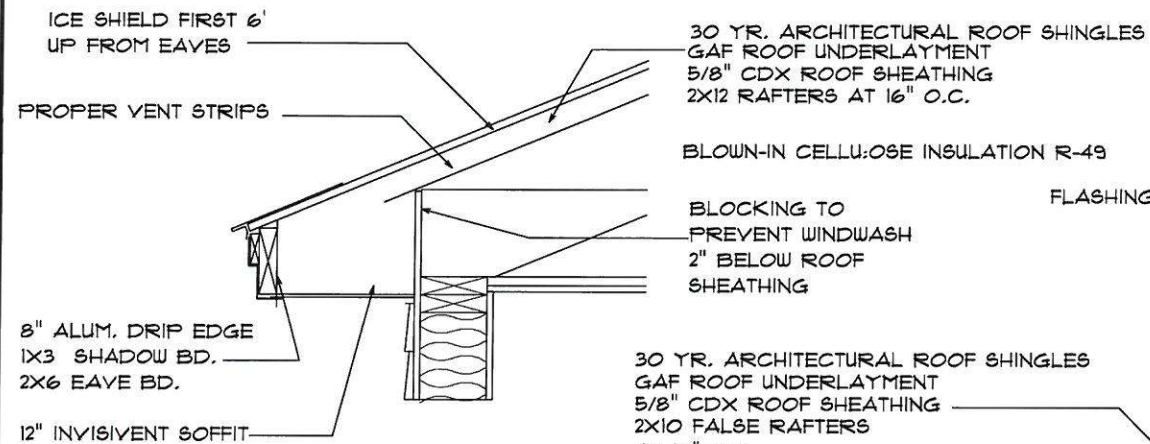

DETAIL "F"
SCALE: 3/16" = 1'-0"

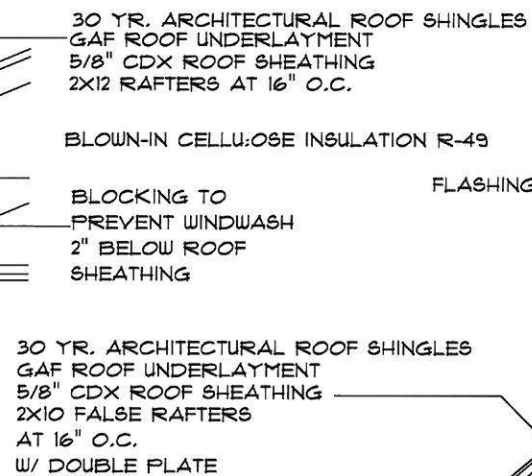


DETAIL "D"
SCALE: 3/16" = 1'-0"

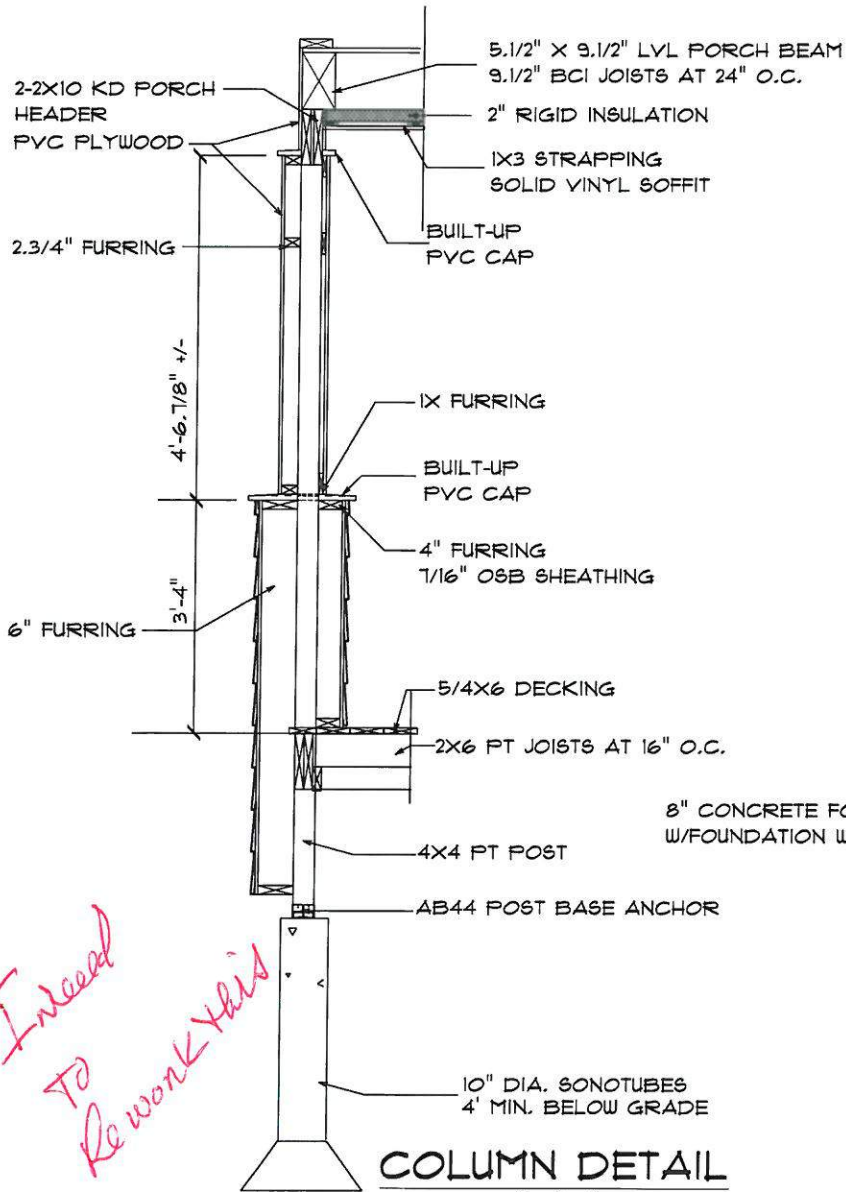


COLUMN DETAIL
SCALE: 3/16" = 1'-0"


*Intend
to
Re-work this*

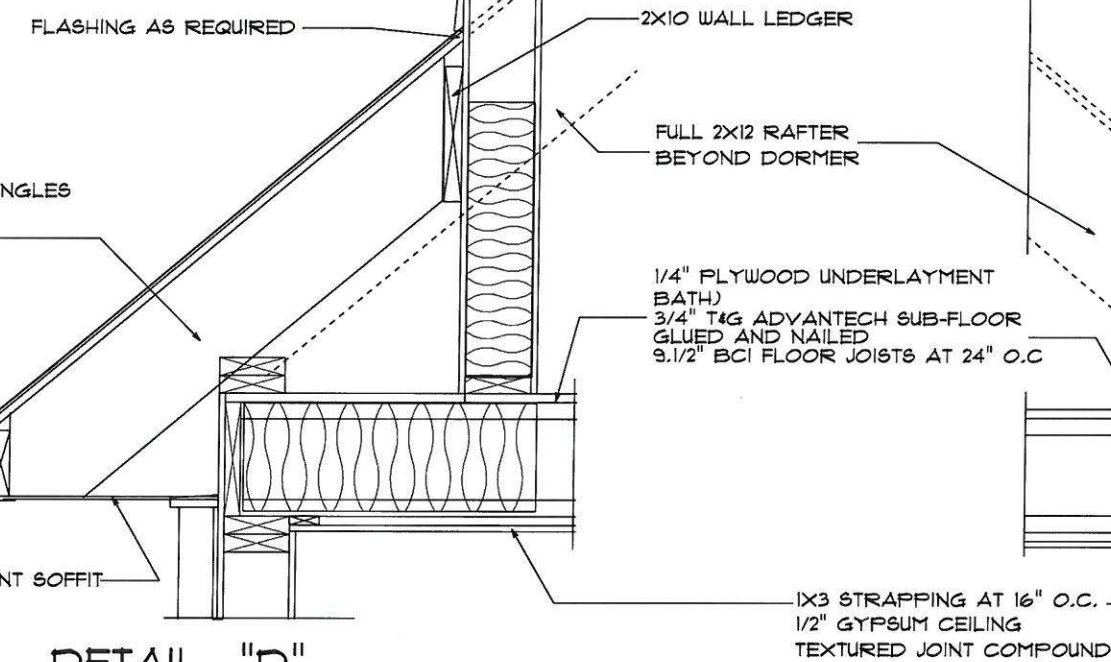


DETAIL "E"
SCALE: 3/16" = 1'-0"

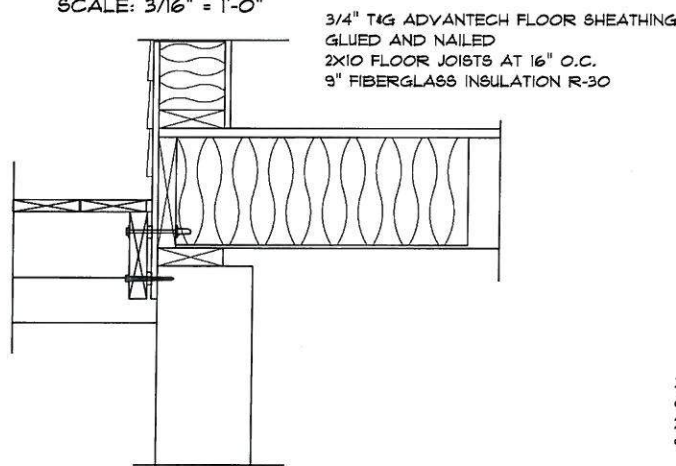

DETAIL "B"
SCALE: 3/16" = 1'-0"

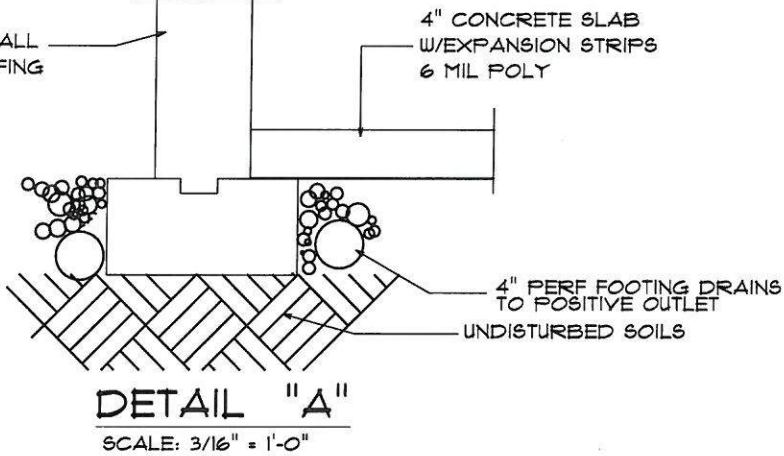

DETAIL "A"
SCALE: 3/16" = 1'-0"

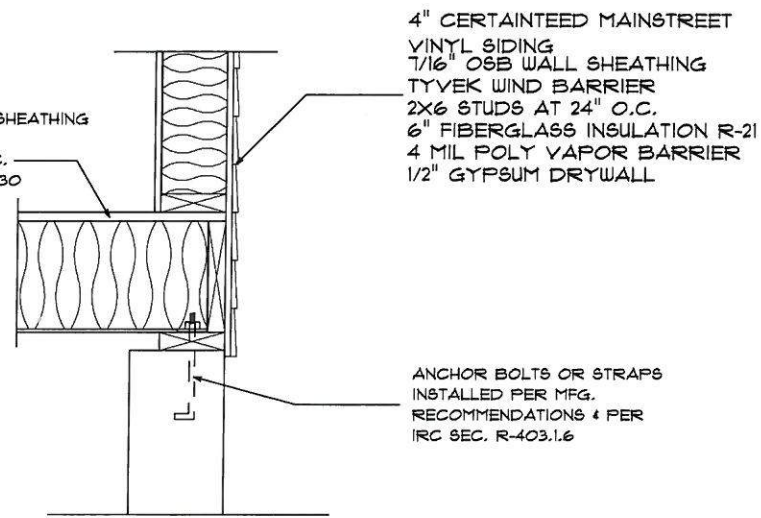

DETAIL "C"
SCALE: 3/16" = 1'-0"

THESE DRAWINGS HAVE BEEN DEVELOPED BY PATCO CONSTRUCTION INC. FOR THE TITLED SET ONLY, THE DRAWINGS ARE THE SOLE PROPERTY OF PATCO CONSTRUCTION INC. AND THEY SHALL NOT BE USED, LENT, ALTERED, OR REPRODUCED WITHOUT WRITTEN CONSENT OF PATCO CONSTRUCTION.

Thursday, August 21, 2014 05:07 PM

REVISIONS:

PATCO
CONSTRUCTION, INC.

1298 MAINE ST. SANFORD, ME. 04073 - 12071324-5574 FAX 12071324-1643
Copyright © 2003 PATCO Construction, Inc. All Rights Reserved.


LOT 1 MORNING STAR
LANE
THE CALLA BUNGALOW CAPE

Woman-Centered Matters

DATE:
AUG. 15, 2014
SCALE:
AS SHOWN
DRAWN BY:
PEL
JOB NO.:
4221
CHK'D BY:

SHEET:

13
OF

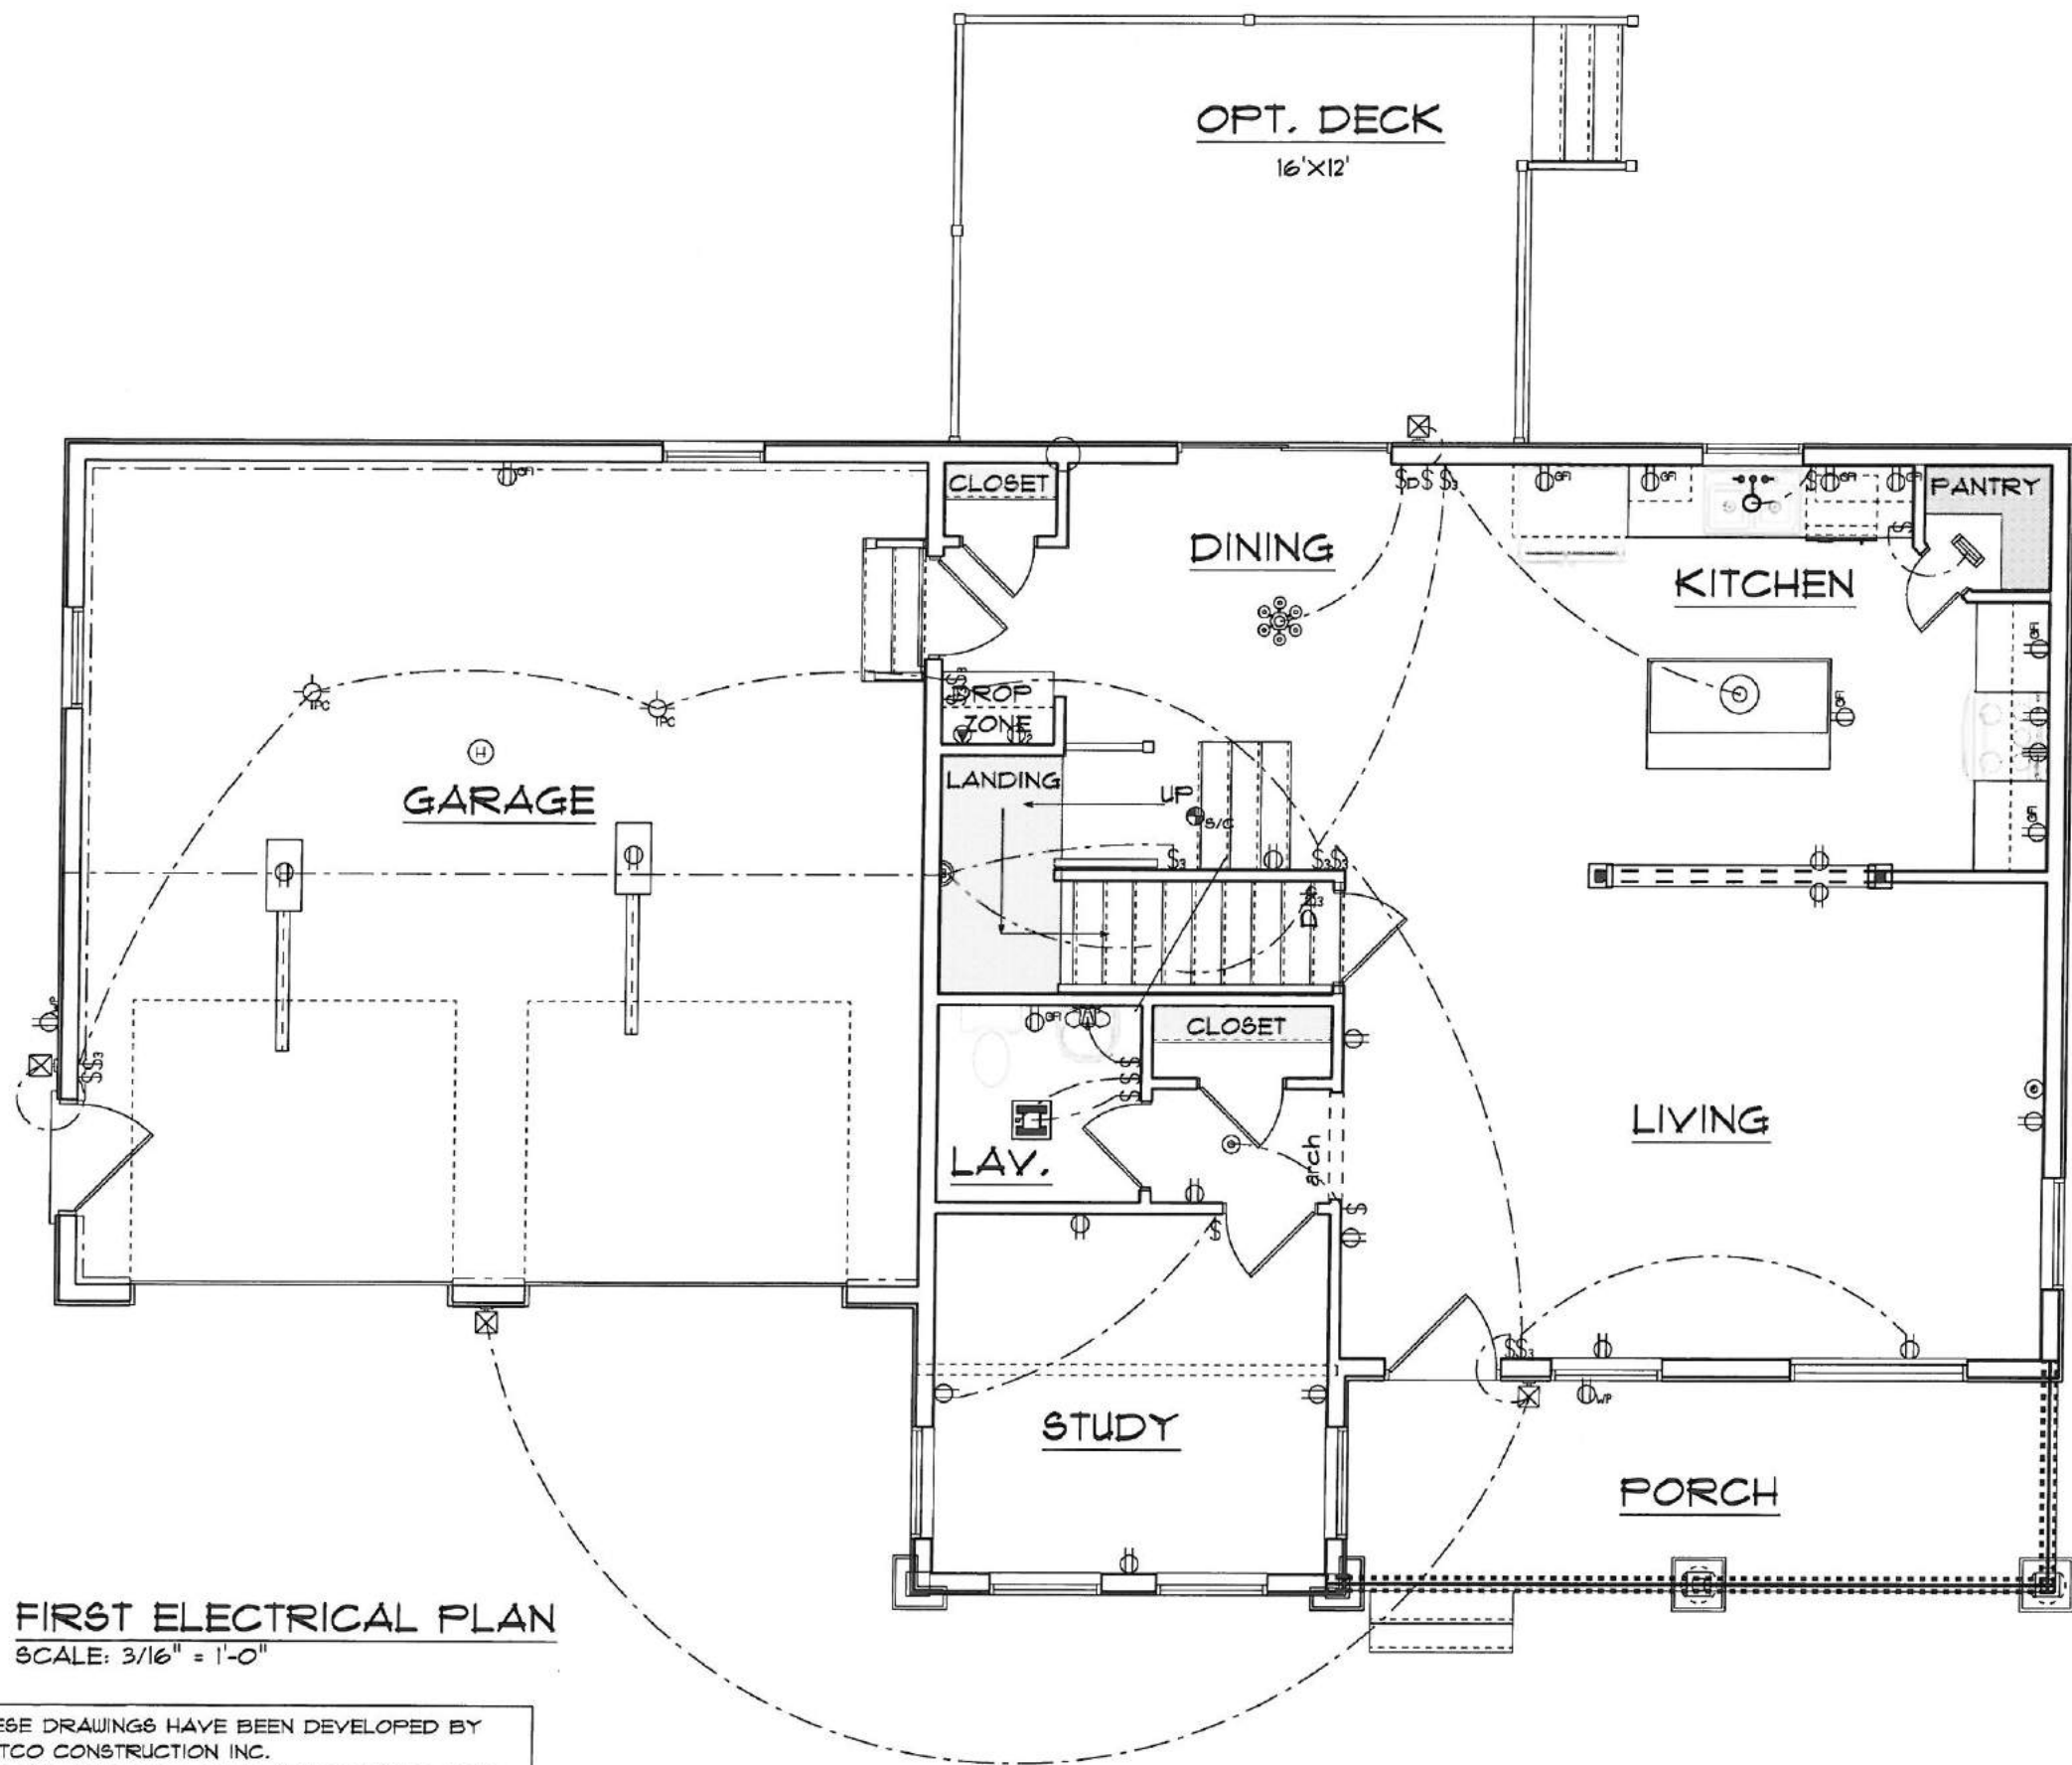

FIRST ELECTRICAL PLAN
SCALE: 3/16" = 1'-0"

THESE DRAWINGS HAVE BEEN DEVELOPED BY PATCO CONSTRUCTION INC. FOR THE TITLED SET ONLY, THE DRAWINGS ARE THE SOLE PROPERTY OF PATCO CONSTRUCTION INC. AND THEY SHALL NOT BE USED, LENT, ALTERED, OR REPRODUCED WITHOUT WRITTEN CONSENT OF PATCO CONSTRUCTION.

ELECTRICAL LEGEND	
ELECTRICAL	SYMBOL
BATH FAN MOTION	
CLOSET FLOURESCENT	
HALL KITCHEN LIGHT	
KITCHEN LIGHT	
CHANDLIER	
EXTERIOR LIGHT	
CABLE TV OUTLET	
GARAGE DOOR OPENER	
OUTLET	
TELEPHONE	
outlet double	
HEAT DETECTOR	
SMOKE CARBON COMBO	
OUTLET	
220V OUTLET	
GFI OUTLET	
WEATHERPROOF OUTLET	
FULL CHAIN LIGHT	
SMOKE DETECTOR	
SWITCH	
3-WAY SWITCH	
SWITCH W/DIMMER	
VANITY LIGHT	
WALL MOUNT LIGHT	
HEAT DETECTOR	

Friday, August 22, 2014

08:19 AM

REVISIONS:

PATCO
CONSTRUCTION, INC.




1293 MAINE ST. SANFORD, ME. 04073 - (207) 322-4557 FAX (207) 322-1643
Copyright © 2003 PATCO Construction, Inc. All Rights Reserved.

LOT 1 MORNING STAR
LANE
THE CALLA BUNGALOW CAPE



DATE:
AUG. 15, 2014
SCALE:
AS SHOWN
DRAWN BY:
PEL
JOB NO.:
4221
CHK'D BY:

SHEET:
14
OF

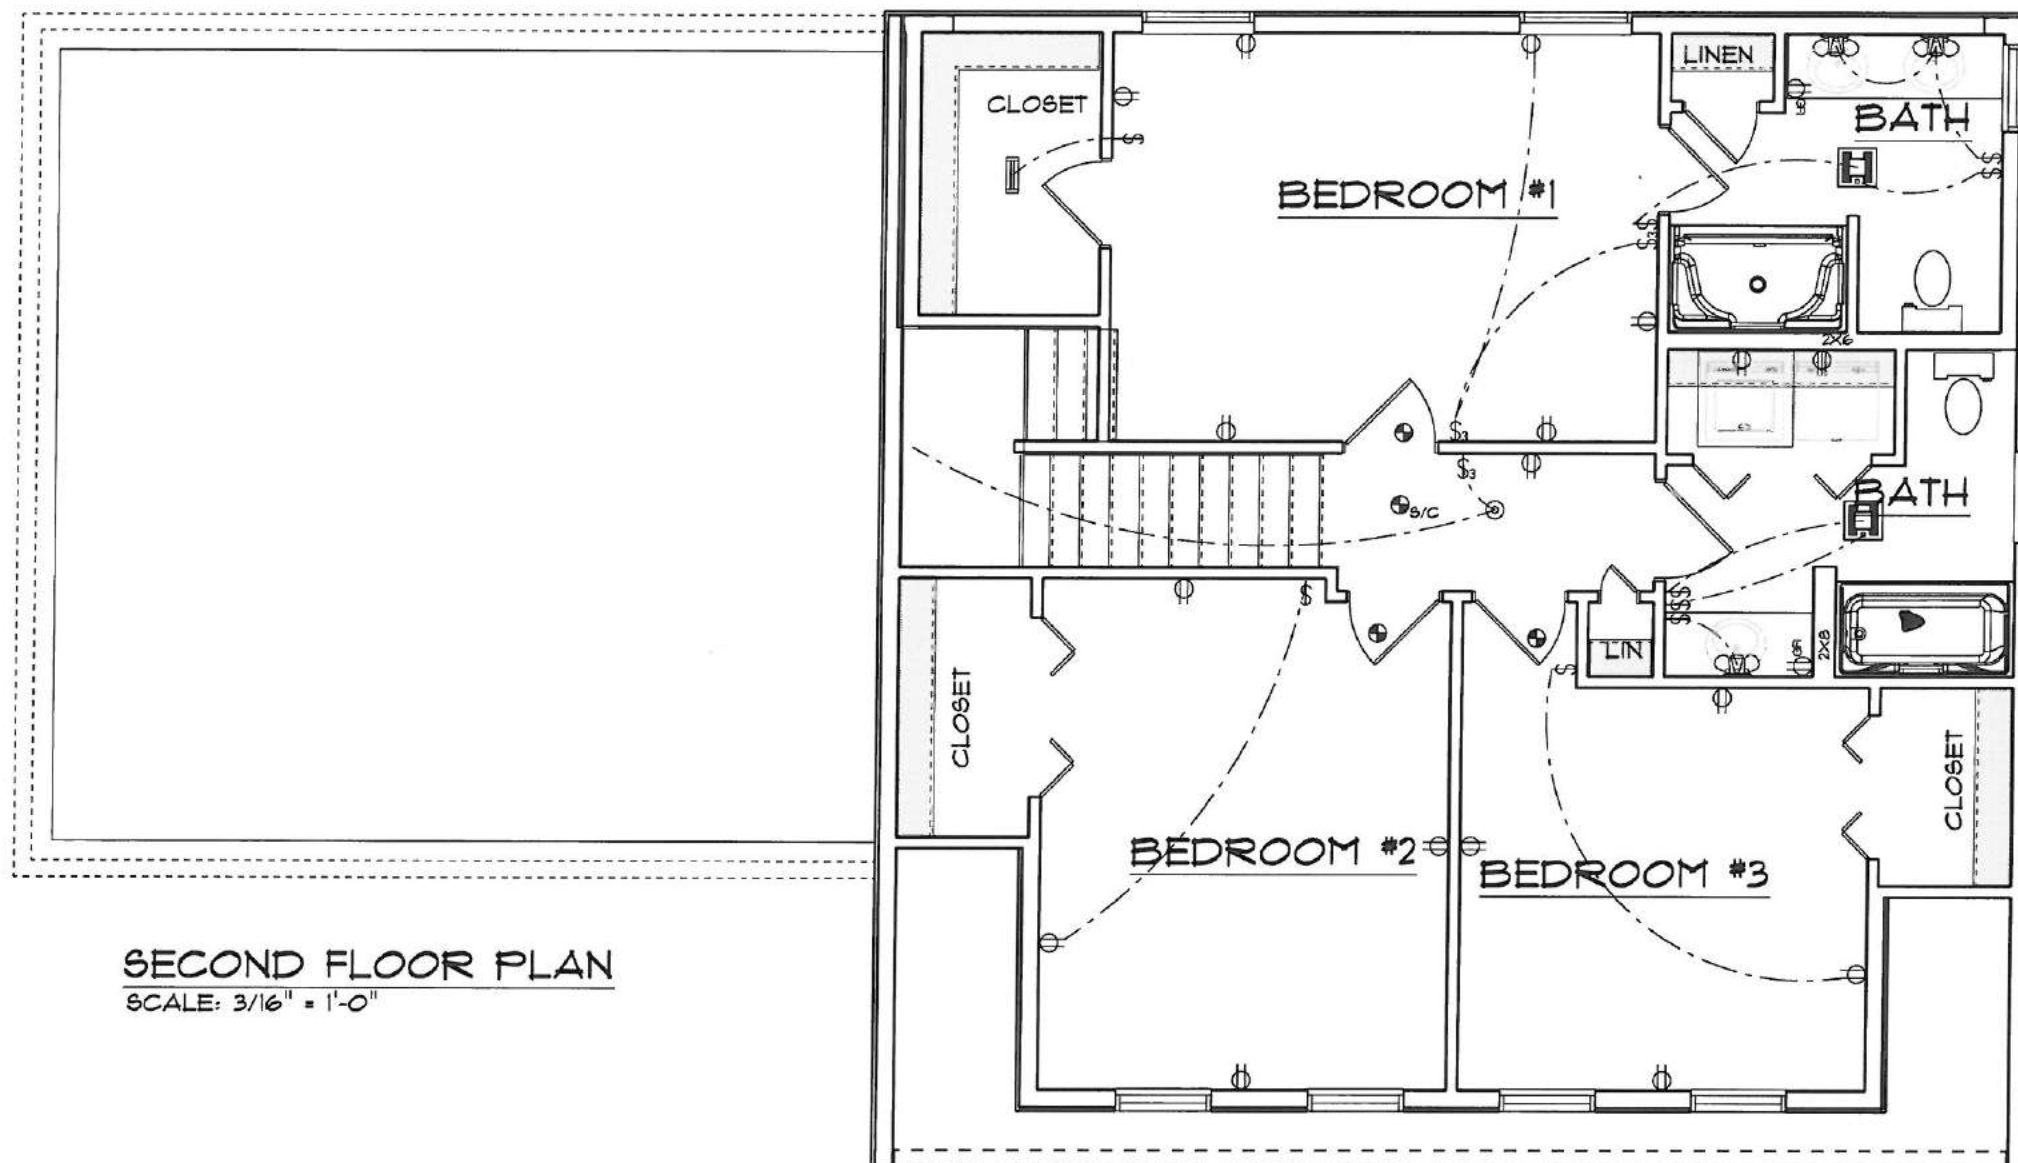


SECOND FLOOR PLAN
SCALE: 3/16" = 1'-0"

THESE DRAWINGS HAVE BEEN DEVELOPED BY PATCO CONSTRUCTION INC. FOR THE TITLED SET ONLY, THE DRAWINGS ARE THE SOLE PROPERTY OF PATCO CONSTRUCTION INC. AND THEY SHALL NOT BE USED, LENT, ALTERED, OR REPRODUCED WITHOUT WRITTEN CONSENT OF PATCO CONSTRUCTION.

Friday, August 22, 2014 08:20 AM

REVISIONS:	
PATCO CONSTRUCTION, INC. 1293 MAINE ST. SANFORD, ME. 04073 - (207)324-5574 FAX (207)324-1643 Copyright © 2003 PATCO Construction, Inc. All Rights Reserved.	
LOT 1 MORNING STAR LANE THE CALLA BUNGALOW CAPE	
 WOMEN-CENTER ARCHITECTS, INC.	
DATE: AUG. 15, 2014	
SCALE: AS SHOWN	
DRAWN BY: PEL	
JOB NO.: 4221	
CH'KD BY:	
SHEET: 14 OF	

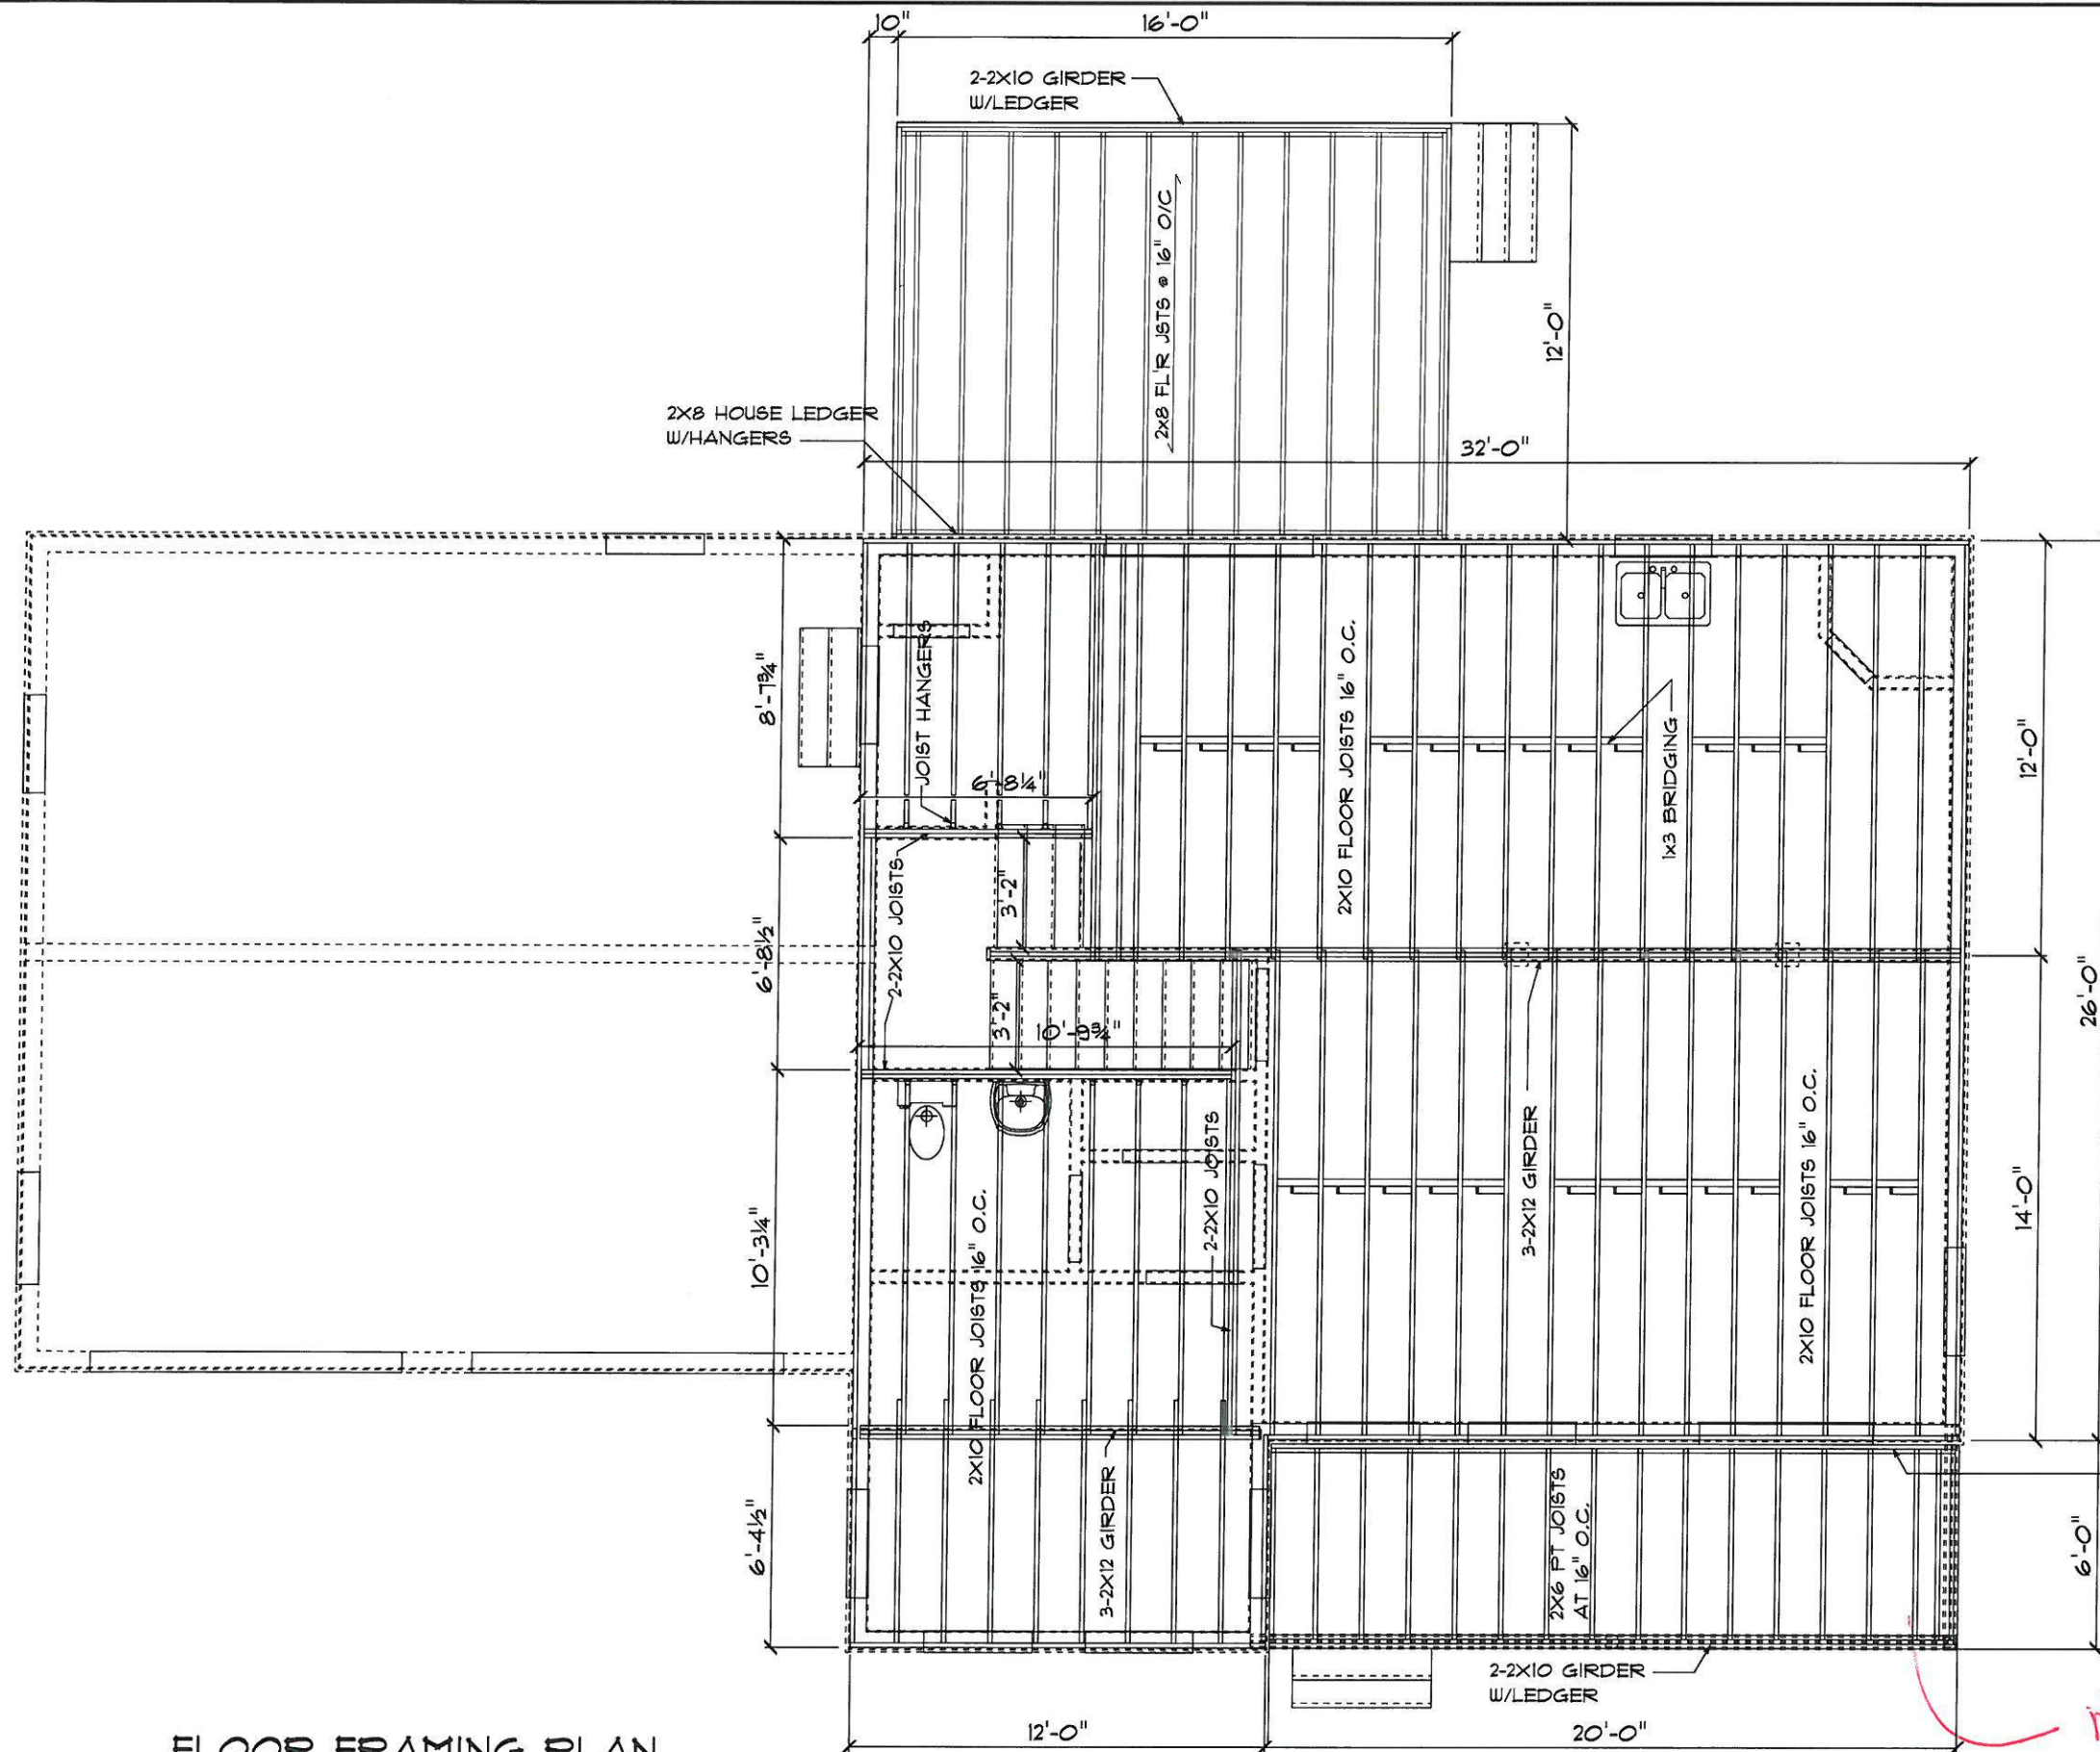

FLOOR FRAMING PLAN
SCALE: 3/16" = 1'-0"

THESE DRAWINGS HAVE BEEN DEVELOPED BY PATCO CONSTRUCTION INC. FOR THE TITLED SET ONLY, THE DRAWINGS ARE THE SOLE PROPERTY OF PATCO CONSTRUCTION INC. AND THEY SHALL NOT BE USED, LENT, ALTERED, OR REPRODUCED WITHOUT WRITTEN CONSENT OF PATCO CONSTRUCTION.

Thursday, August 21, 2014 09:22 AM

REVISIONS:



PATCO
CONSTRUCTION, INC.

1293 MAINE ST. SANFORD, ME. 04073 - 12071324-5574 FAX 12071324-1643
Copyright © 2003 PATCO Construction, Inc. All Rights Reserved.

LOT 1 MORNING STAR
LANE
THE CALLA BUNGALOW CAPE

Woman-Centric Matters

DATE:	AUG. 15, 2014
SCALE:	AS SHOWN
DRAWN BY:	PEL
JOB NO.:	4221
CH'KD BY:	
SHEET:	15 OF

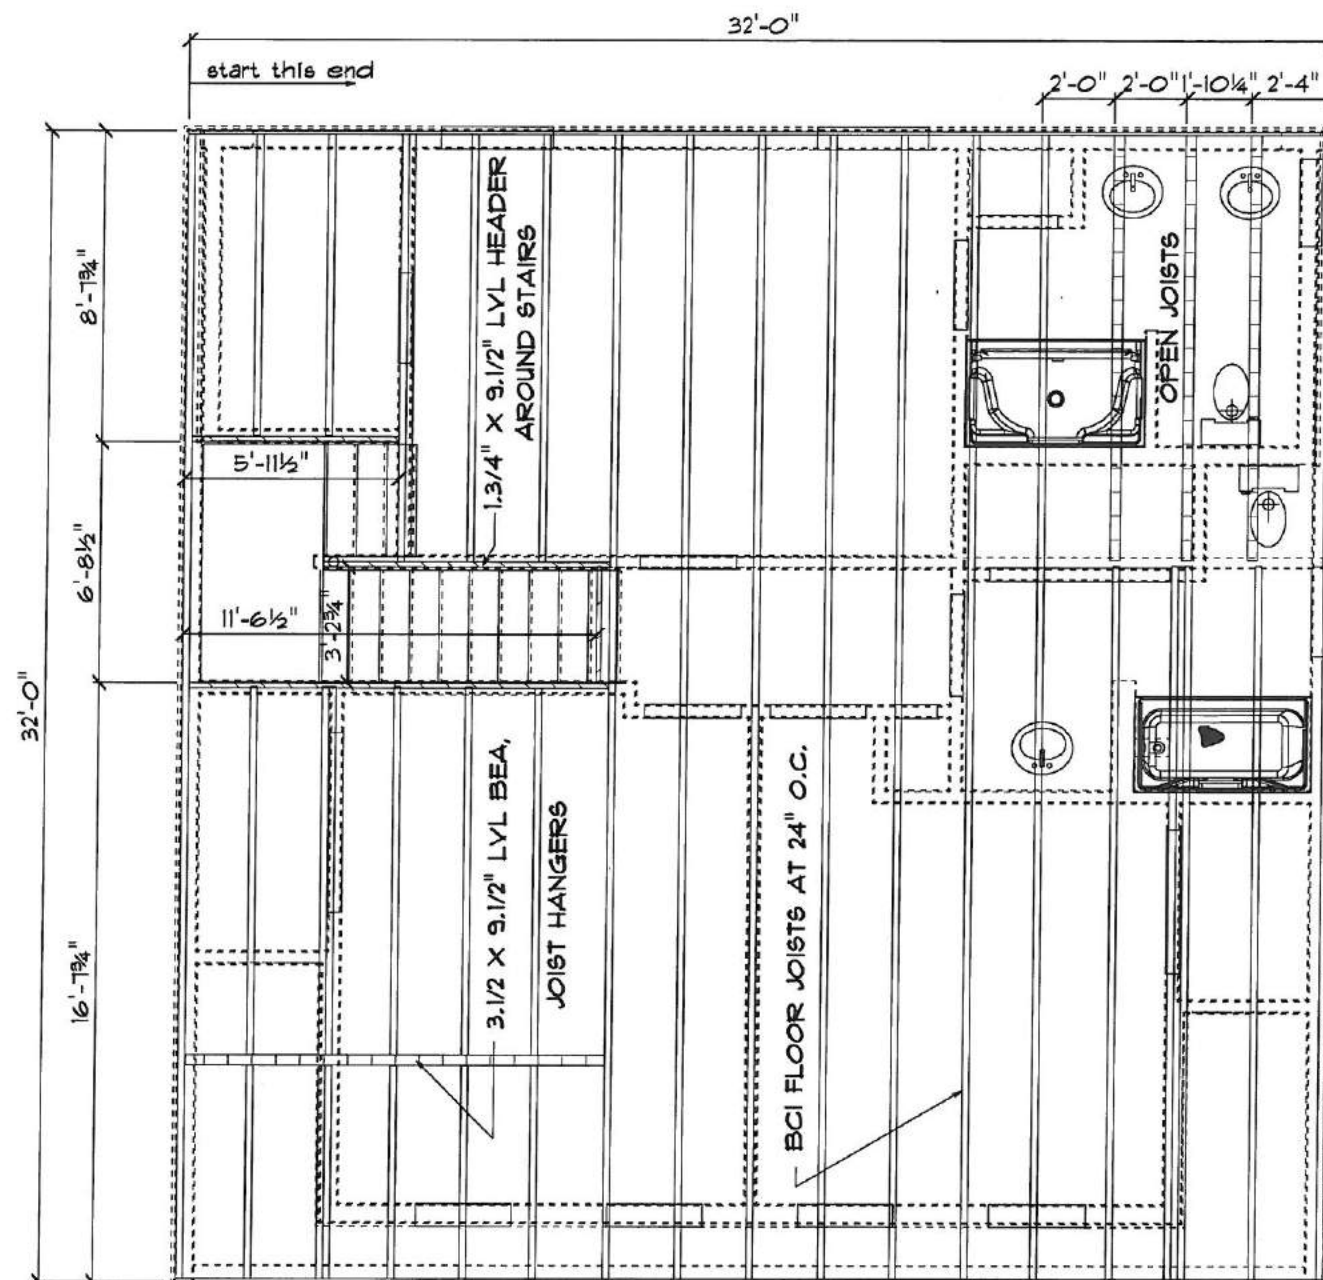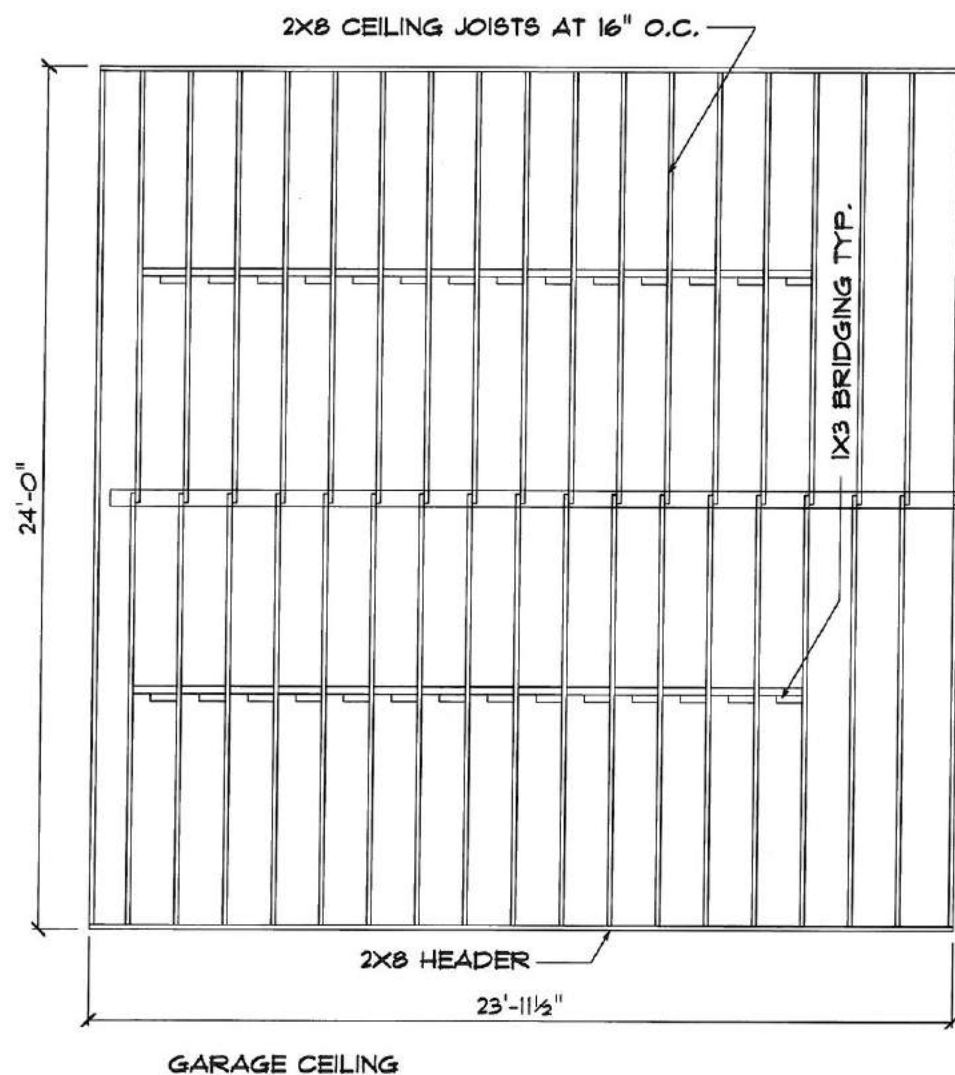

SECOND FLOOR FRAMING PLAN
SCALE: 3/16" = 1'-0"

THESE DRAWINGS HAVE BEEN DEVELOPED BY PATCO CONSTRUCTION INC. FOR THE TITLED SET ONLY, THE DRAWINGS ARE THE SOLE PROPERTY OF PATCO CONSTRUCTION INC. AND THEY SHALL NOT BE USED, LENT, ALTERED, OR REPRODUCED WITHOUT WRITTEN CONSENT OF PATCO CONSTRUCTION.

Friday, August 22, 2014

08:33 AM

REVISIONS:

PATCO
CONSTRUCTION, INC.

1293 MAINE ST. SANFORD, ME. 04073 - (207)324-5574 FAX (207)324-1643
Copyright © 2003 PATCO Construction, Inc. All Rights Reserved.

LOT 1 MORNING STAR
LANE
THE CALLA BUNGALOW CAPE




DATE:
AUG. 15, 2014
SCALE:
AS SHOWN
DRAWN BY:
PEL
JOB NO.:
4221
CHK'D BY:

SHEET:

16
OF



08:37 AM

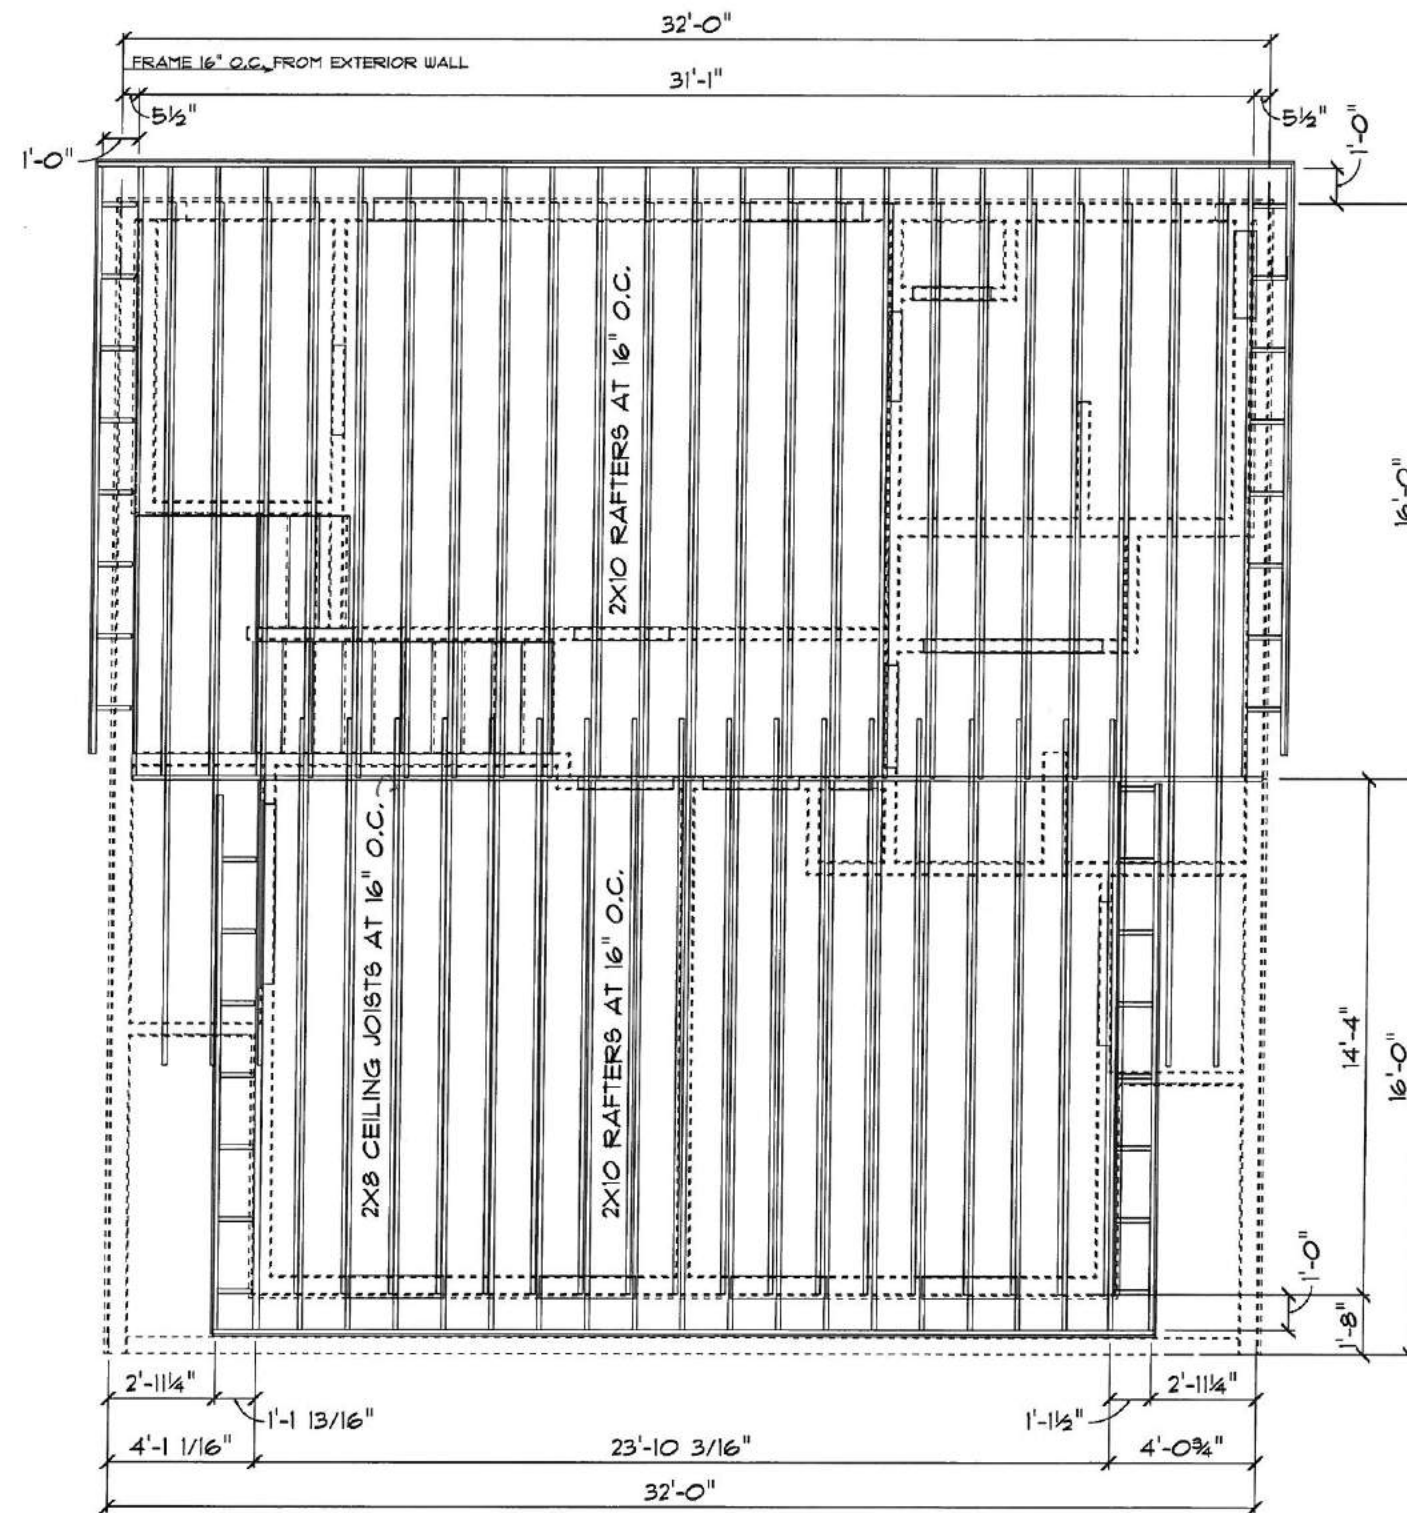

DORMER ROOF FRAMING/CEILING PLAN
SCALE: 3/16" = 1'-0"

THESE DRAWINGS HAVE BEEN DEVELOPED BY PATCO CONSTRUCTION INC. FOR THE TITLED SET ONLY, THE DRAWINGS ARE THE SOLE PROPERTY OF PATCO CONSTRUCTION INC. AND THEY SHALL NOT BE USED, LENT, ALTERED, OR REPRODUCED WITHOUT WRITTEN CONSENT OF PATCO CONSTRUCTION.

Wednesday, August 20, 2014 02:48 PM

REVISIONS:



1293 MAINE ST. SANFORD, ME. 04073 - (207) 324-5574 FAX (207) 324-1643
Copyright © 2003 PATCO Construction, Inc. All Rights Reserved.


LOT 1 MORNING STAR
LANE
THE CALLA BUNGALOW CAPE



DATE:
AUG. 15, 2014
SCALE:
AS SHOWN
DRAWN BY:
PEL
JOB NO.:
4221
CH'KD BY:

SHEET:

18
OF

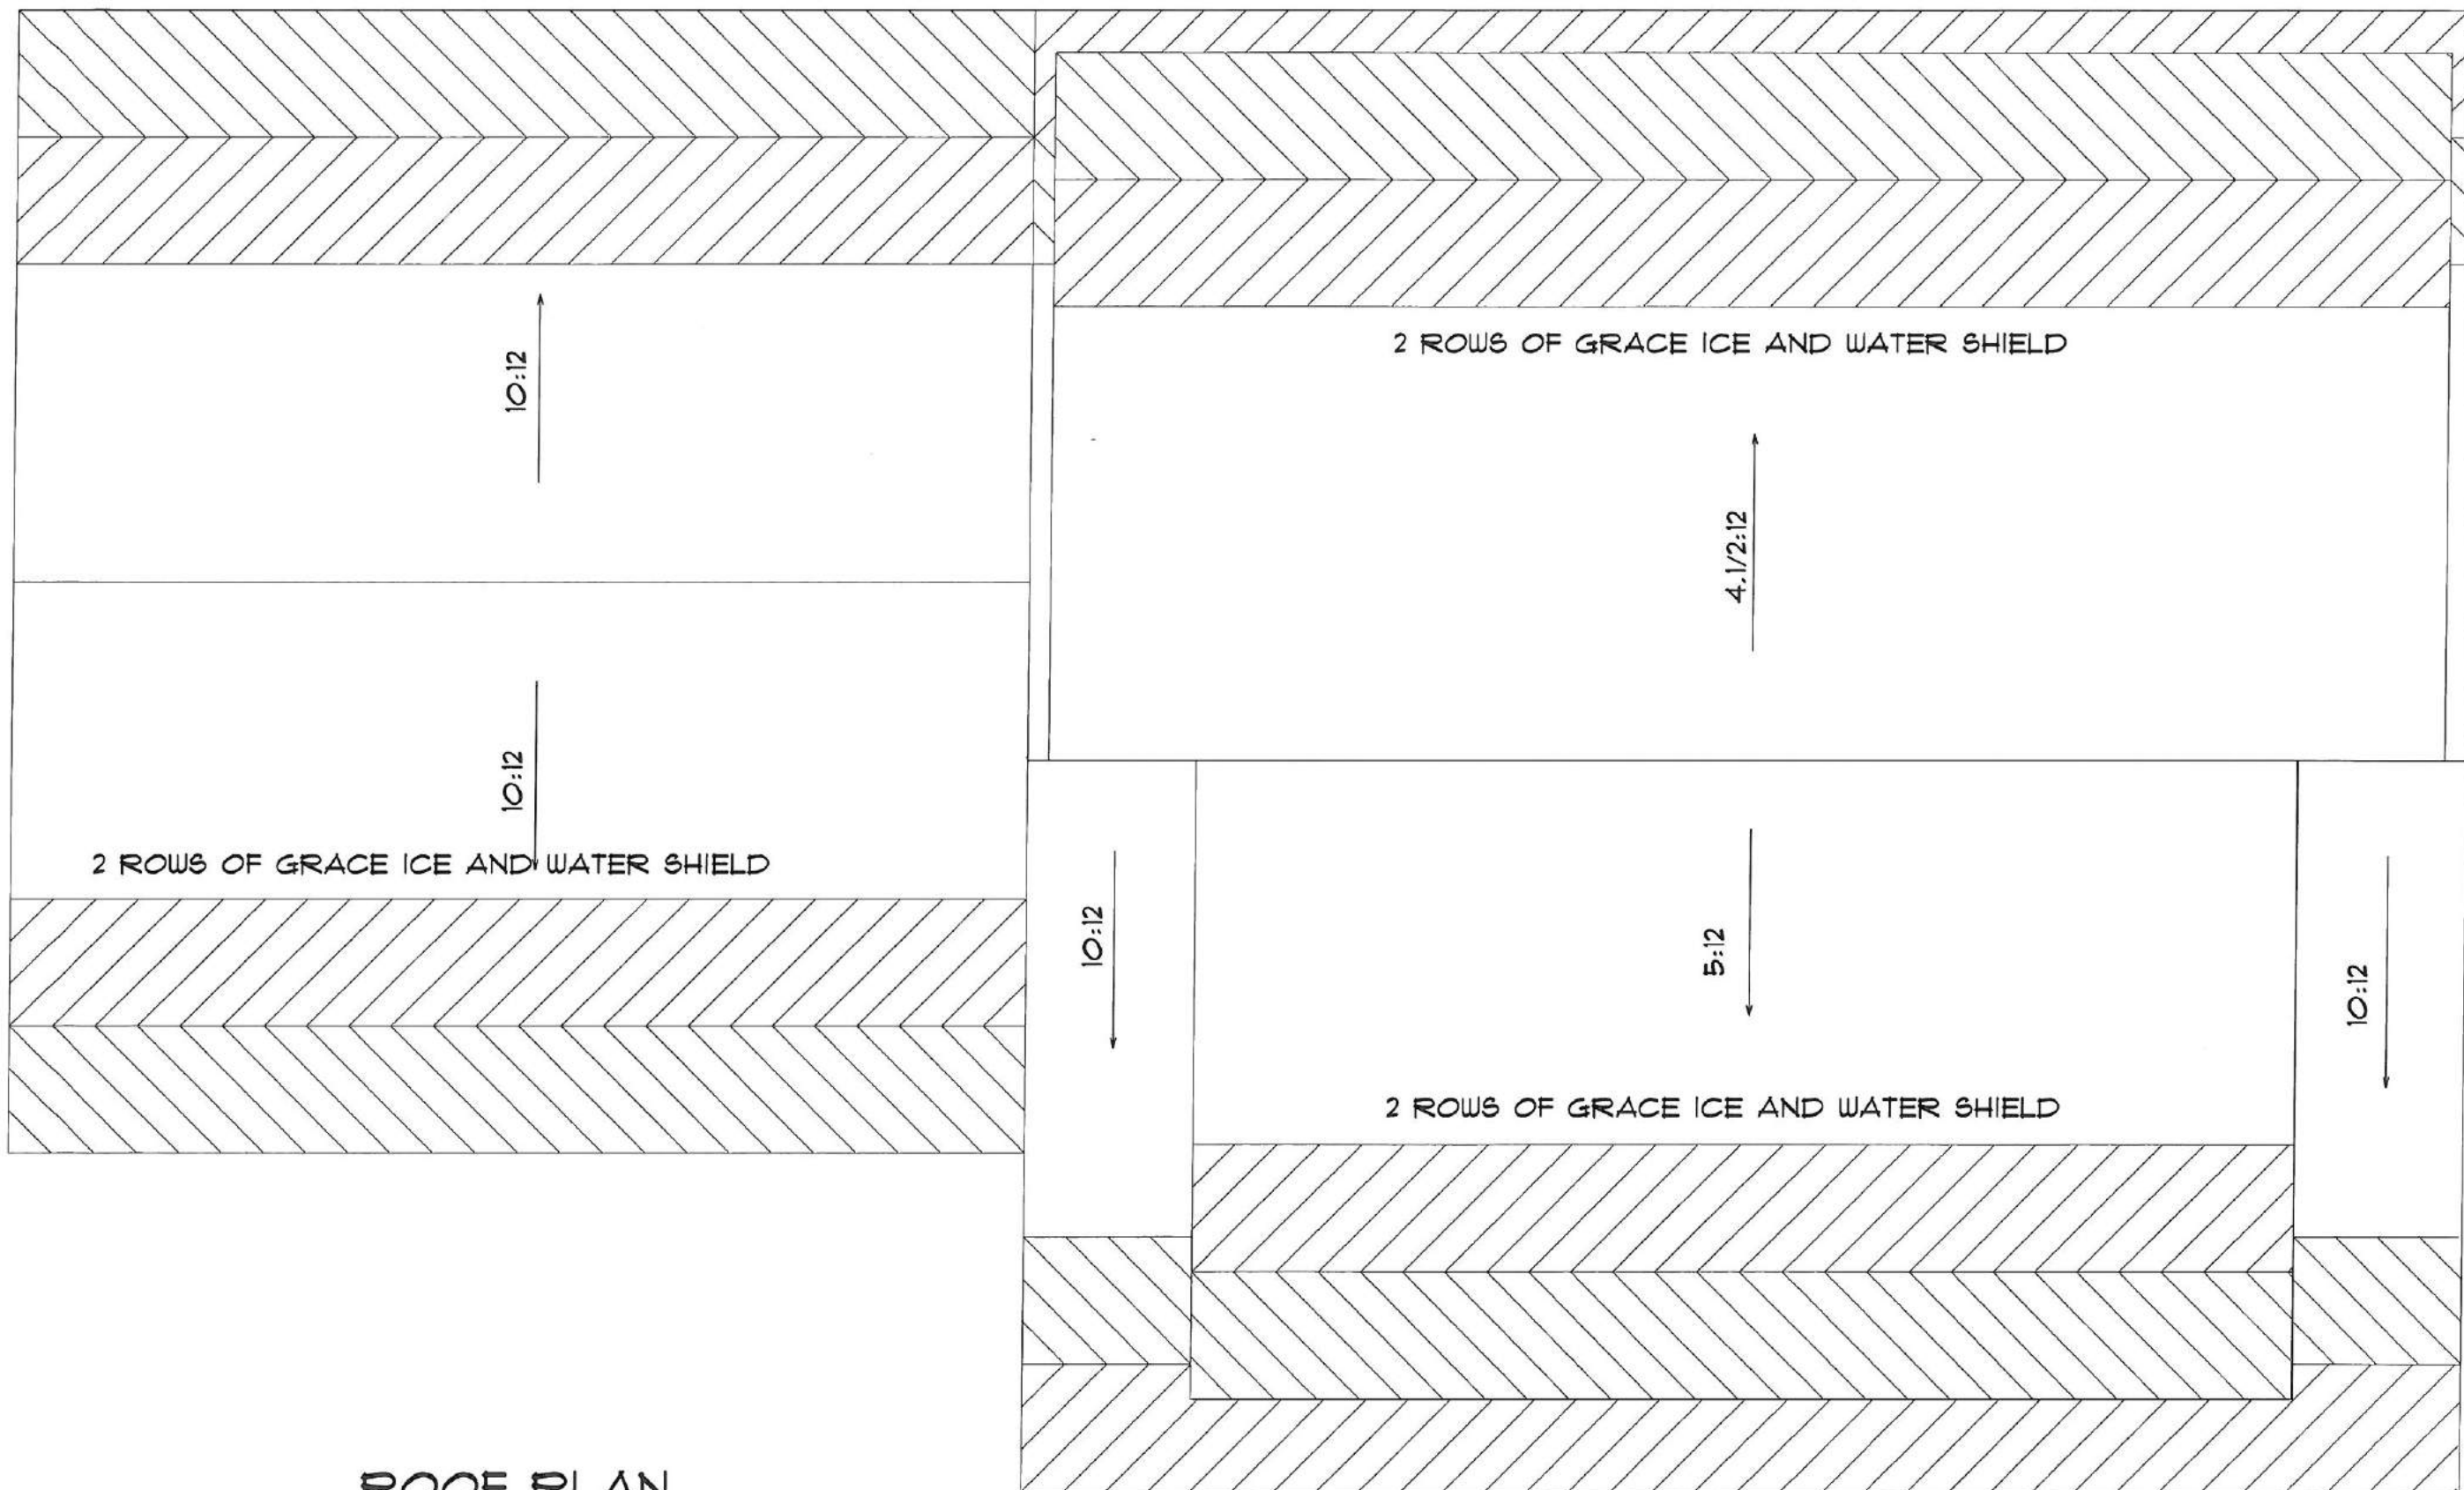

ROOF PLAN
SCALE: 1/4" = 1'-0"

THESE DRAWINGS HAVE BEEN DEVELOPED BY PATCO CONSTRUCTION INC. FOR THE TITLED SET ONLY, THE DRAWINGS ARE THE SOLE PROPERTY OF PATCO CONSTRUCTION INC. AND THEY SHALL NOT BE USED, LENT, ALTERED, OR REPRODUCED WITHOUT WRITTEN CONSENT OF PATCO CONSTRUCTION.

Friday, August 22, 2014 08:40 AM

REVISIONS:



1293 MAINE ST. SANFORD, ME. 04073 - 12071324-5574 FAX 12071324-1643
Copyright © 2003 PATCO Construction, Inc. All Rights Reserved.

LOT 1 MORNING STAR

LANE

THE CALLA BUNGALOW CAPE




DATE:
AUG. 15, 2014
SCALE:
AS SHOWN
DRAWN BY:
PEL
JOB NO.:
4221
CHKD BY:

SHEET:

19
OF

OPENING PREP. FOR RESIDENTIAL

JAMB DETAIL

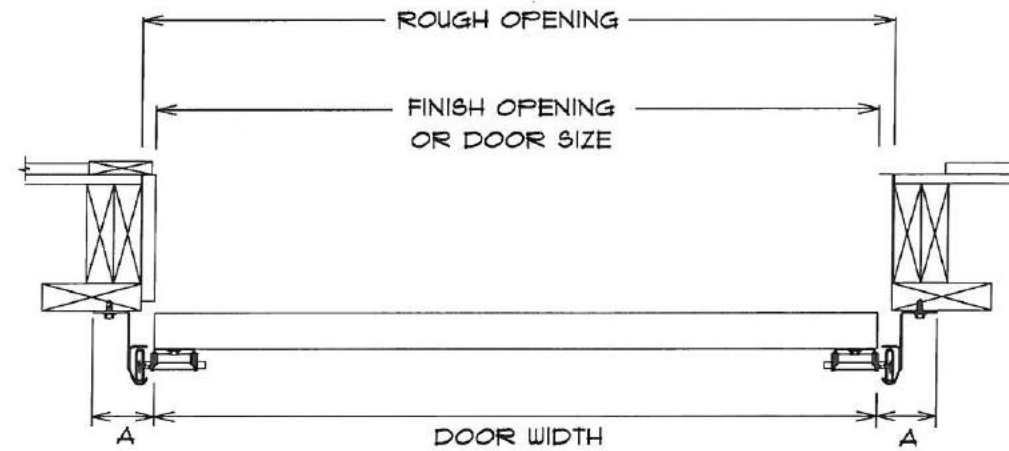

DIMENSION A - SIDE ROOM REQUIRED
 3 1/2" ALL STANDARD LIFT DOORS
 6" ALL LOW HEADROOM DOORS
 2 x 6 JAMBS TYP.


REFER TO PLANS
 FOR HEADER DETAIL

1'-0"

CONCRETE FLOOR

2 x 8 MOUNTING PAD
 FOR OPERATOR & TORSION
 SPRINGS (IF SUPPLIED)

4'-6"

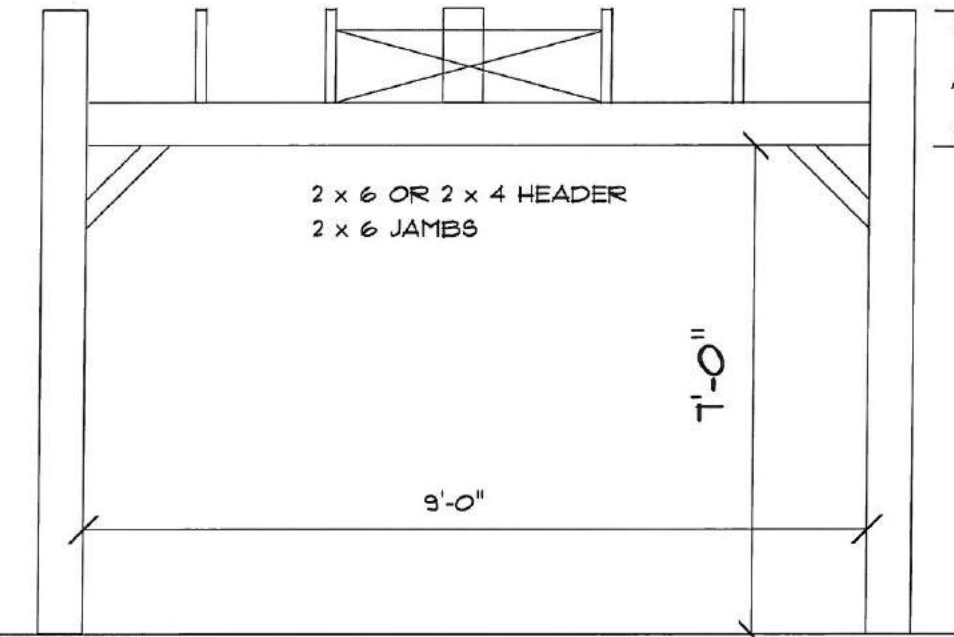

FINISH FLOOR (MUST BE LEVEL)

A - 12" STANDARD LIFT TRACK
 A - 5" LOW HEADROOM TRACK
 ADD 2" FOR ELECTRIC OPERATORS

HEADROOM REQUIRED
 (CLEAR DISTANCE ABOVE
 OPENING HEIGHT)

OVERHEAD DOOR DETAIL

N.T.S.

THESE DRAWINGS HAVE BEEN DEVELOPED BY PATCO CONSTRUCTION INC.
 FOR THE TITLED SET ONLY, THE DRAWINGS ARE THE SOLE PROPERTY OF
 PATCO CONSTRUCTION INC. AND THEY SHALL NOT BE USED, LENT, ALTERED,
 OR REPRODUCED WITHOUT WRITTEN CONSENT OF PATCO CONSTRUCTION.

Friday, August 22, 2014

09:02 AM

REVISIONS:

PATCO
 CONSTRUCTION, INC.

1293 MAINE ST. SANFORD, ME 04073 - 12071924-5574 FAX 12071924-1643
 Copyright © 2003 PATCO Construction, Inc. All Rights Reserved.



LOT 1 MORNING STAR
 LANE
 THE CALLA BUNGALOW CAPE

W
 womancentered minimalist

DATE:
 AUG. 15, 2014
 SCALE:
 AS SHOWN
 DRAWN BY:
 PEL
 JOB NO.:
 4221
 CH'KD BY:


SHEET:

20
 OF

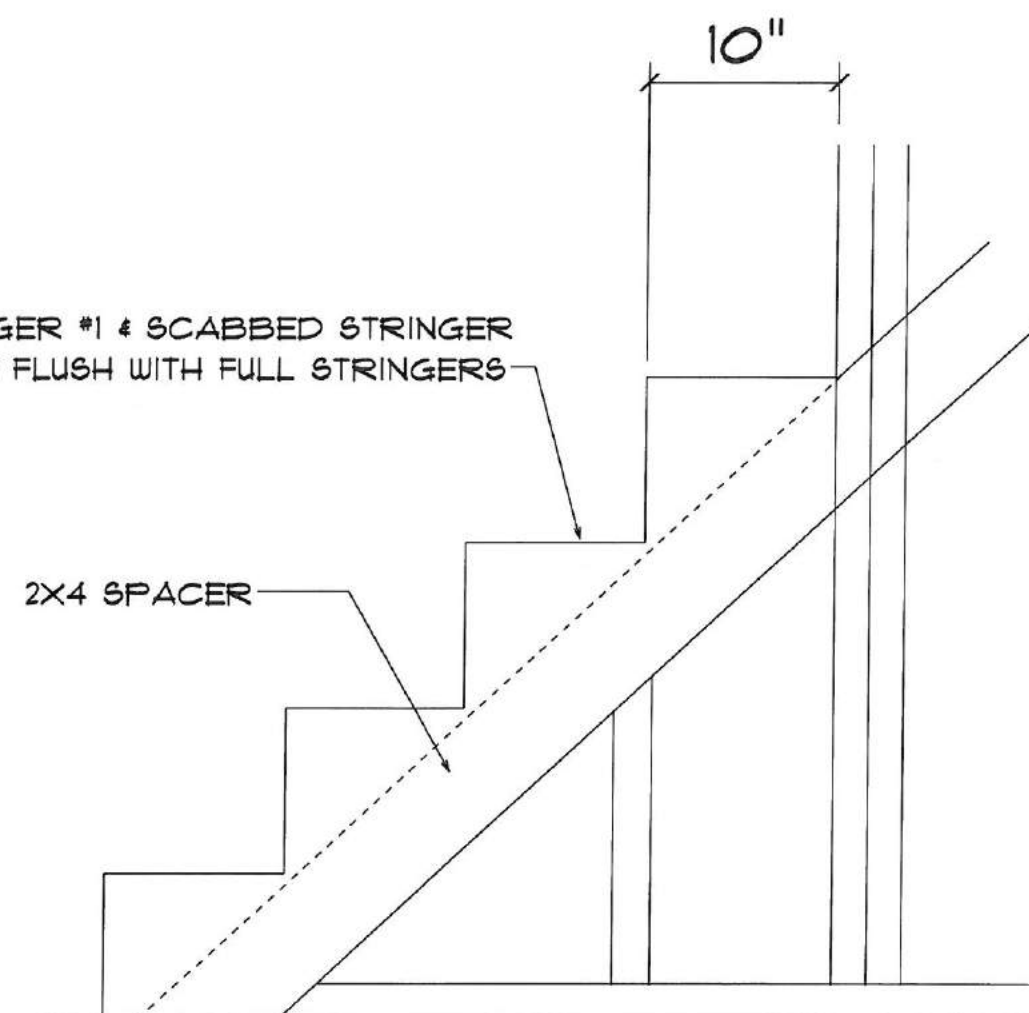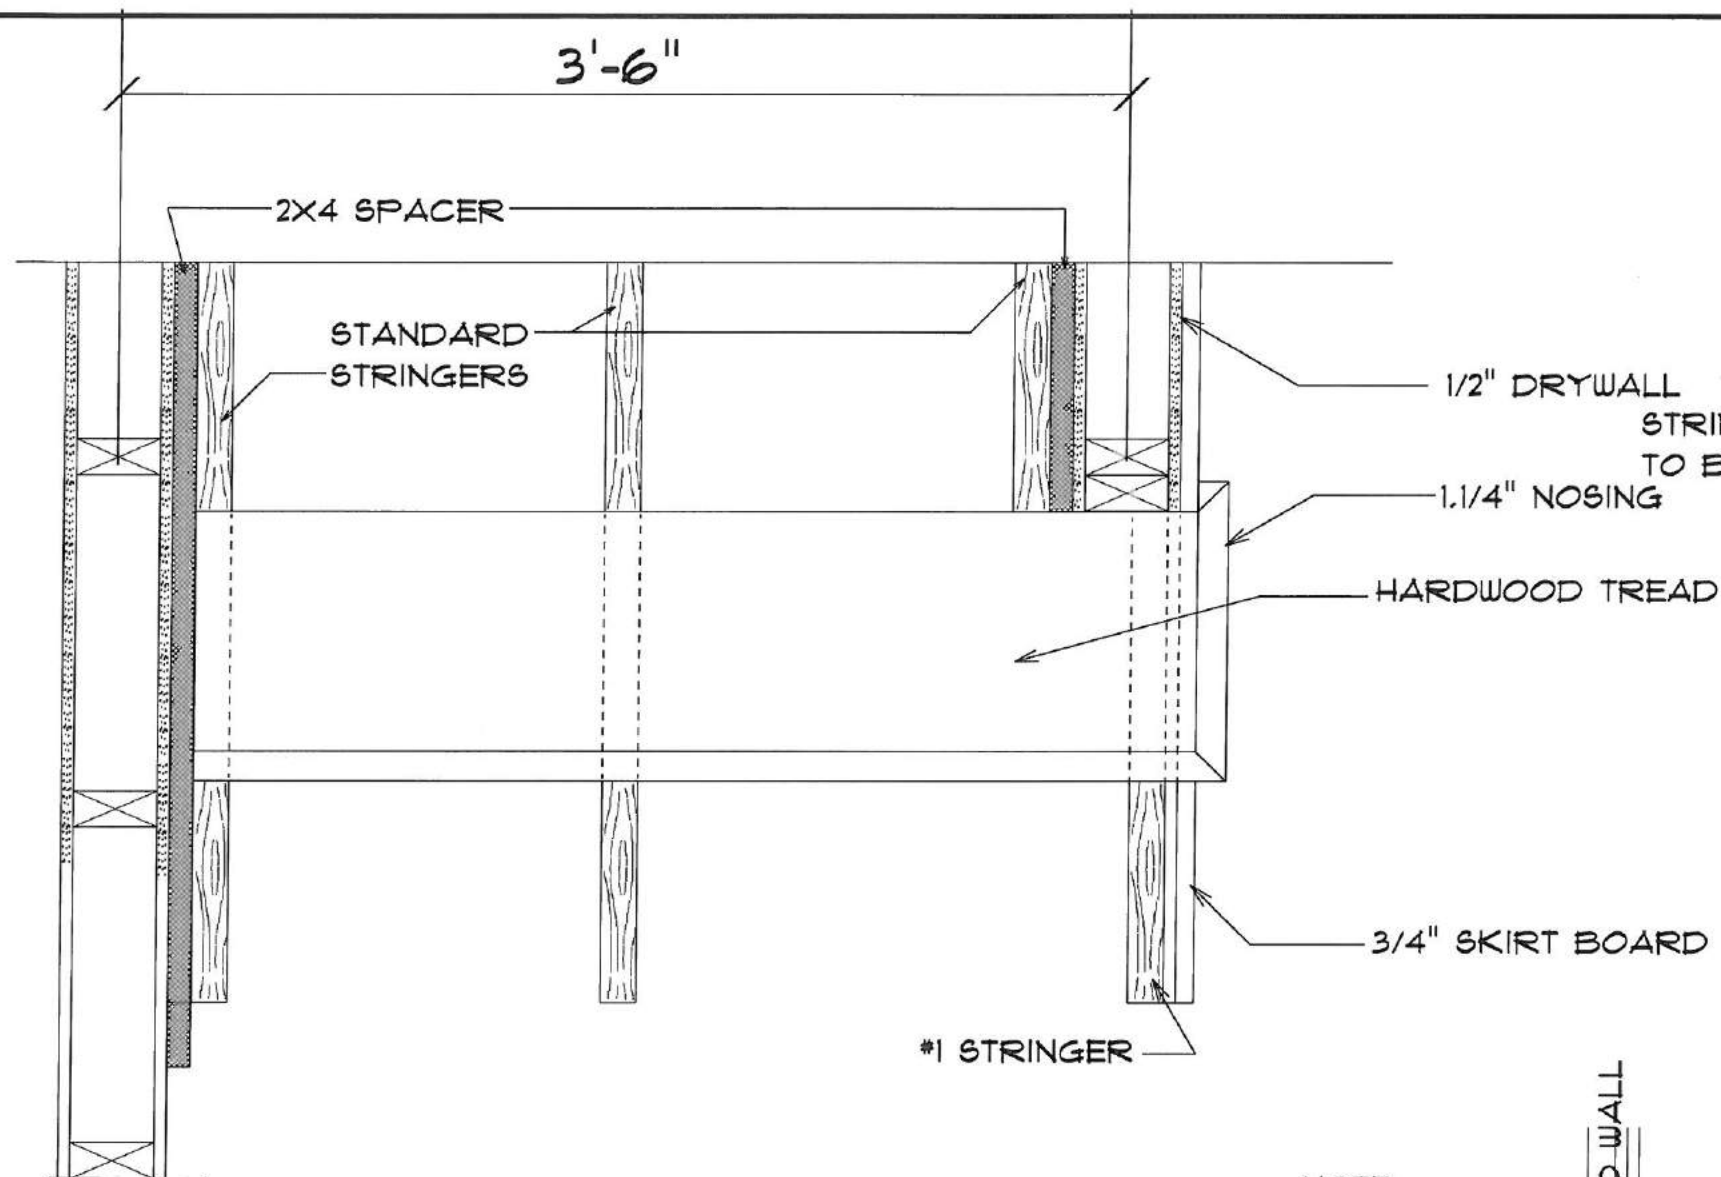

NOTE:
BALANCE OF TREADS AND RISERS TO BE
3/4" UNDERLAYMENT PLYWOOD

FULL HARDWOOD TREADS
FIRST 4 TREADS ONLY
PAINTED PINE RISERS

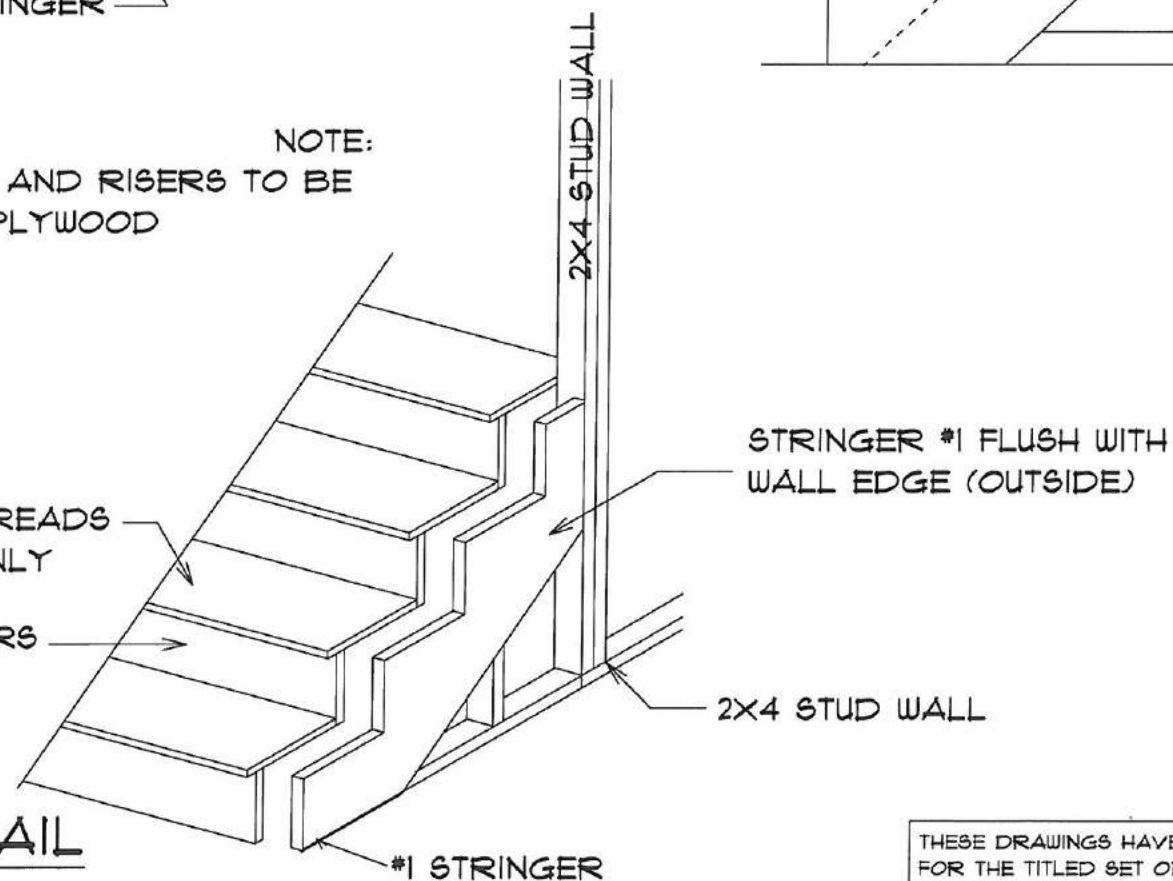

HARDWOOD TREAD FRAMING DETAIL

NO SCALE:

THESE DRAWINGS HAVE BEEN DEVELOPED BY PATCO CONSTRUCTION INC.
FOR THE TITLED SET ONLY, THE DRAWINGS ARE THE SOLE PROPERTY OF
PATCO CONSTRUCTION INC. AND THEY SHALL NOT BE USED, LENT, ALTERED,
OR REPRODUCED WITHOUT WRITTEN CONSENT OF PATCO CONSTRUCTION.

Friday, August 22, 2014 09:01 AM

REVISIONS:

PATCO
CONSTRUCTION, INC.

1293 MAINE ST. SANFORD, ME. 04073 - (207) 324-5574 FAX (207) 324-1643
Copyright © 2003 PATCO Construction, Inc. All Rights Reserved.


LOT 1 MORNING STAR
LANE
THE CALLA BUNGALOW CAPE

W
WOMEN-CENTRIC
methodology

DATE:
AUG. 15, 2014
SCALE:
AS SHOWN
DRAWN BY:
PEL
JOB NO.:
4221
CHKD BY:

SHEET:


21
OF

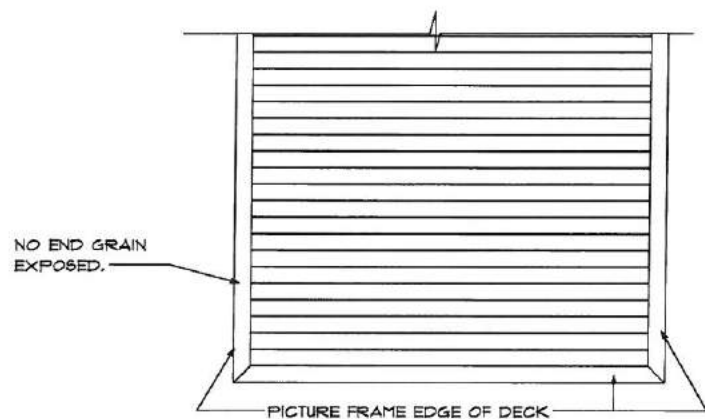


TYPICAL DECKING DETAIL

SCALE: NTS

CUT AT
45 DEGREE ANGLE

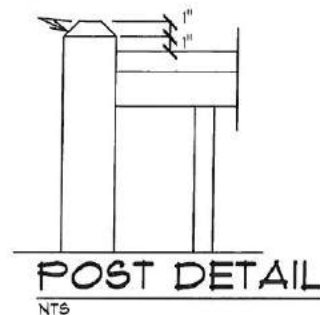


TOP VIEW
NTS

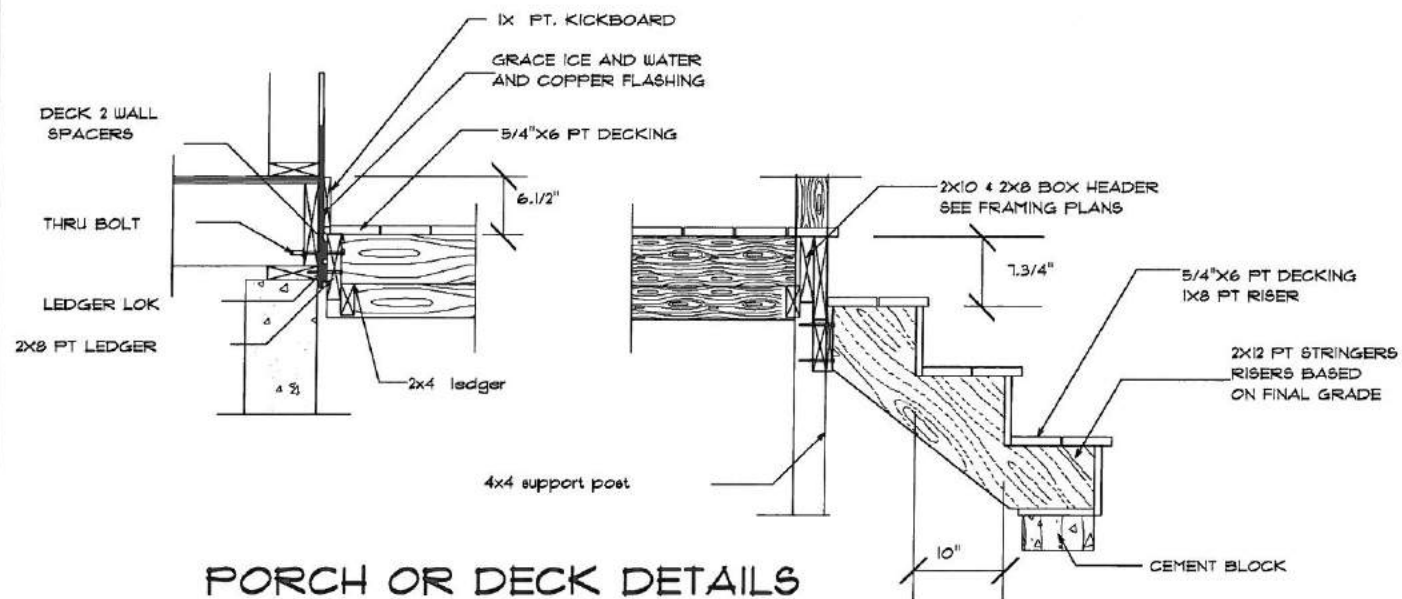


PORCH OR DECK DETAILS

SCALE: 3/4" = 1'-0"

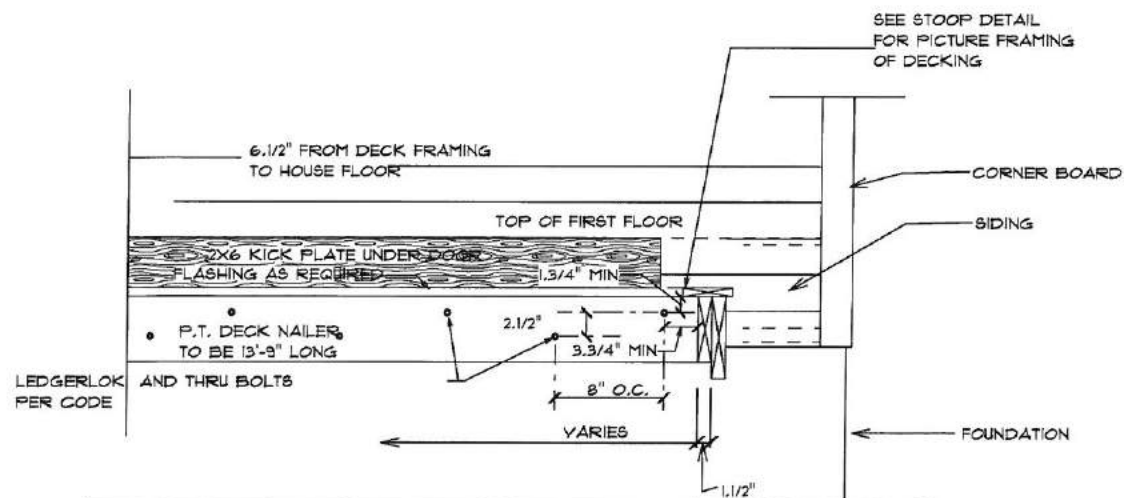


NAILER DETAIL

NTS

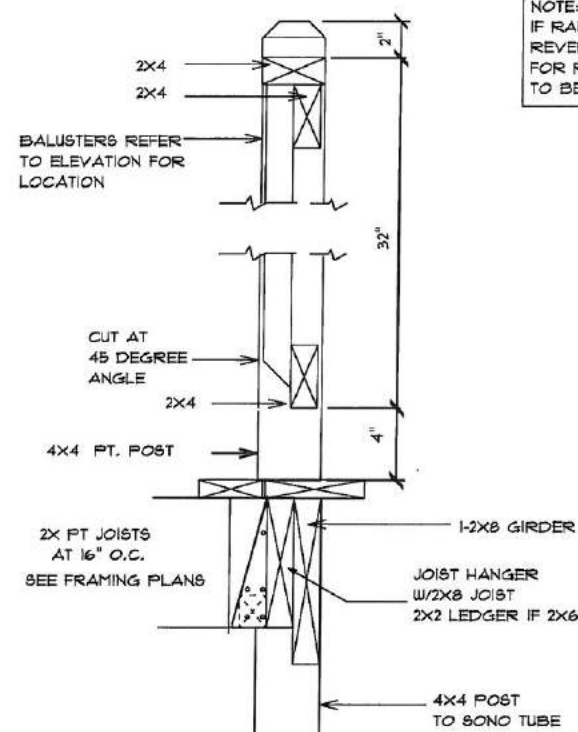

PT DECK RAIL POST DETAILS

NOTE:
NO MORE THAN 4"
BETWEEN BALUSTERS

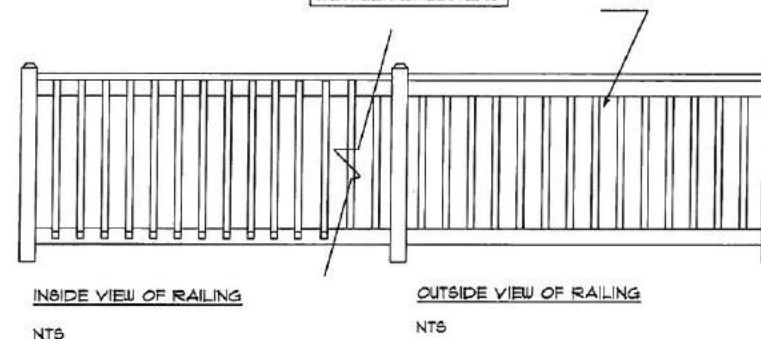

RAILING ELEVATIONS

THESE DRAWINGS HAVE BEEN DEVELOPED BY PATCO CONSTRUCTION INC. FOR THE TITLED SET ONLY, THE DRAWINGS ARE THE SOLE PROPERTY OF PATCO CONSTRUCTION INC. AND THEY SHALL NOT BE USED, LENT, ALTERED, OR REPRODUCED WITHOUT WRITTEN CONSENT OF PATCO CONSTRUCTION.

REVISIONS:

PATCO
CONSTRUCTION, INC.

1293 MAINE ST. SANFORD, ME. 04073 - 12071324-5574 FAX 12071324-1643
Copyright © 2003 PATCO Construction, Inc. All Rights Reserved.

LOT 1 MORNING STAR
LANE
THE CALLA BUNGALOW CAPE

W
WOMEN-CENTRIC
method

DATE:
AUG. 15, 2014
SCALE:
AS SHOWN
DRAWN BY:
FEL
JOB NO.:
4221
CHK'D BY:

SHEET:

22

OF

Friday, August 22, 2014

09:28 AM